

SHEET INDEX	
#	DESCRIPTION
1	SITE PLAN
2	FOUNDATION PLAN
3	1ST FLOOR PLAN
4	ROOF PLAN
5	FRONT & REAR ELEVATIONS
6	SIDE ELEVATIONS
7	ELECTRICAL PLAN

RDS

CALEB - 1

DATE: 11.4.16

COPYRIGHT 2016 R.D.S. ALL RIGHTS RESERVED. NO PART OF THESE DRAWINGS ARE TO BE REPRODUCED OR TRANSMITTED IN ANY FORM OR BY ANY MEANS, ELECTRONIC OR MECHANICAL, WITHOUT THE WRITTEN PERMISSION OF THE DESIGNER. THESE DRAWINGS ARE THE EXCLUSIVE PROPERTY OF THE DESIGNER, AND ARE NOT TO BE USED IN WHOLE OR PART FOR ANY OTHER PROJECT WITHOUT THE WRITTEN PERMISSION OF THE DESIGNER. UNAUTHORIZED USE OF THESE DRAWINGS WILL BE THE RESPONSIBILITY OF THE USER TO LEGAL REMEDY WILL BE SOUGHT BY THE DESIGNER.

3206 FALL CREEK HIGHWAY • GRANBURY, TX 76049
PH: 817-326-2547 FAX: 817-326-2548
J ALLEN HOMES ARCHITECTS, P.C.
ARCHITECTURAL DESIGN ONLY. CIVIL, STRUCTURAL, MECHANICAL, AND OTHER RELATED ENGINEERING DESIGN AND SPECIFICATIONS ARE NOT INCLUDED IN THESE DRAWINGS. THE USER SHALL BE RESPONSIBLE FOR OBTAINING ALL NECESSARY PERMITS AND COMPLIANCE TO THESE DRAWINGS WILL BE THE RESPONSIBILITY OF THE GENERAL CONTRACTOR. ALL MEASUREMENTS SHALL BE VERIFIED BY THE CONTRACTORS DURING THE RESPECTIVE WORK.

J ALLEN HOMES

CALEB PLAN - 1 STORY

GRANBURY, TX

RESIDENTIAL

DESIGN STUDIO

FINAL

FOR CONSTRUCTION


5

ELEVATIONS



FRONT ELEVATION - A

SCALE: 1" = 1'-0"

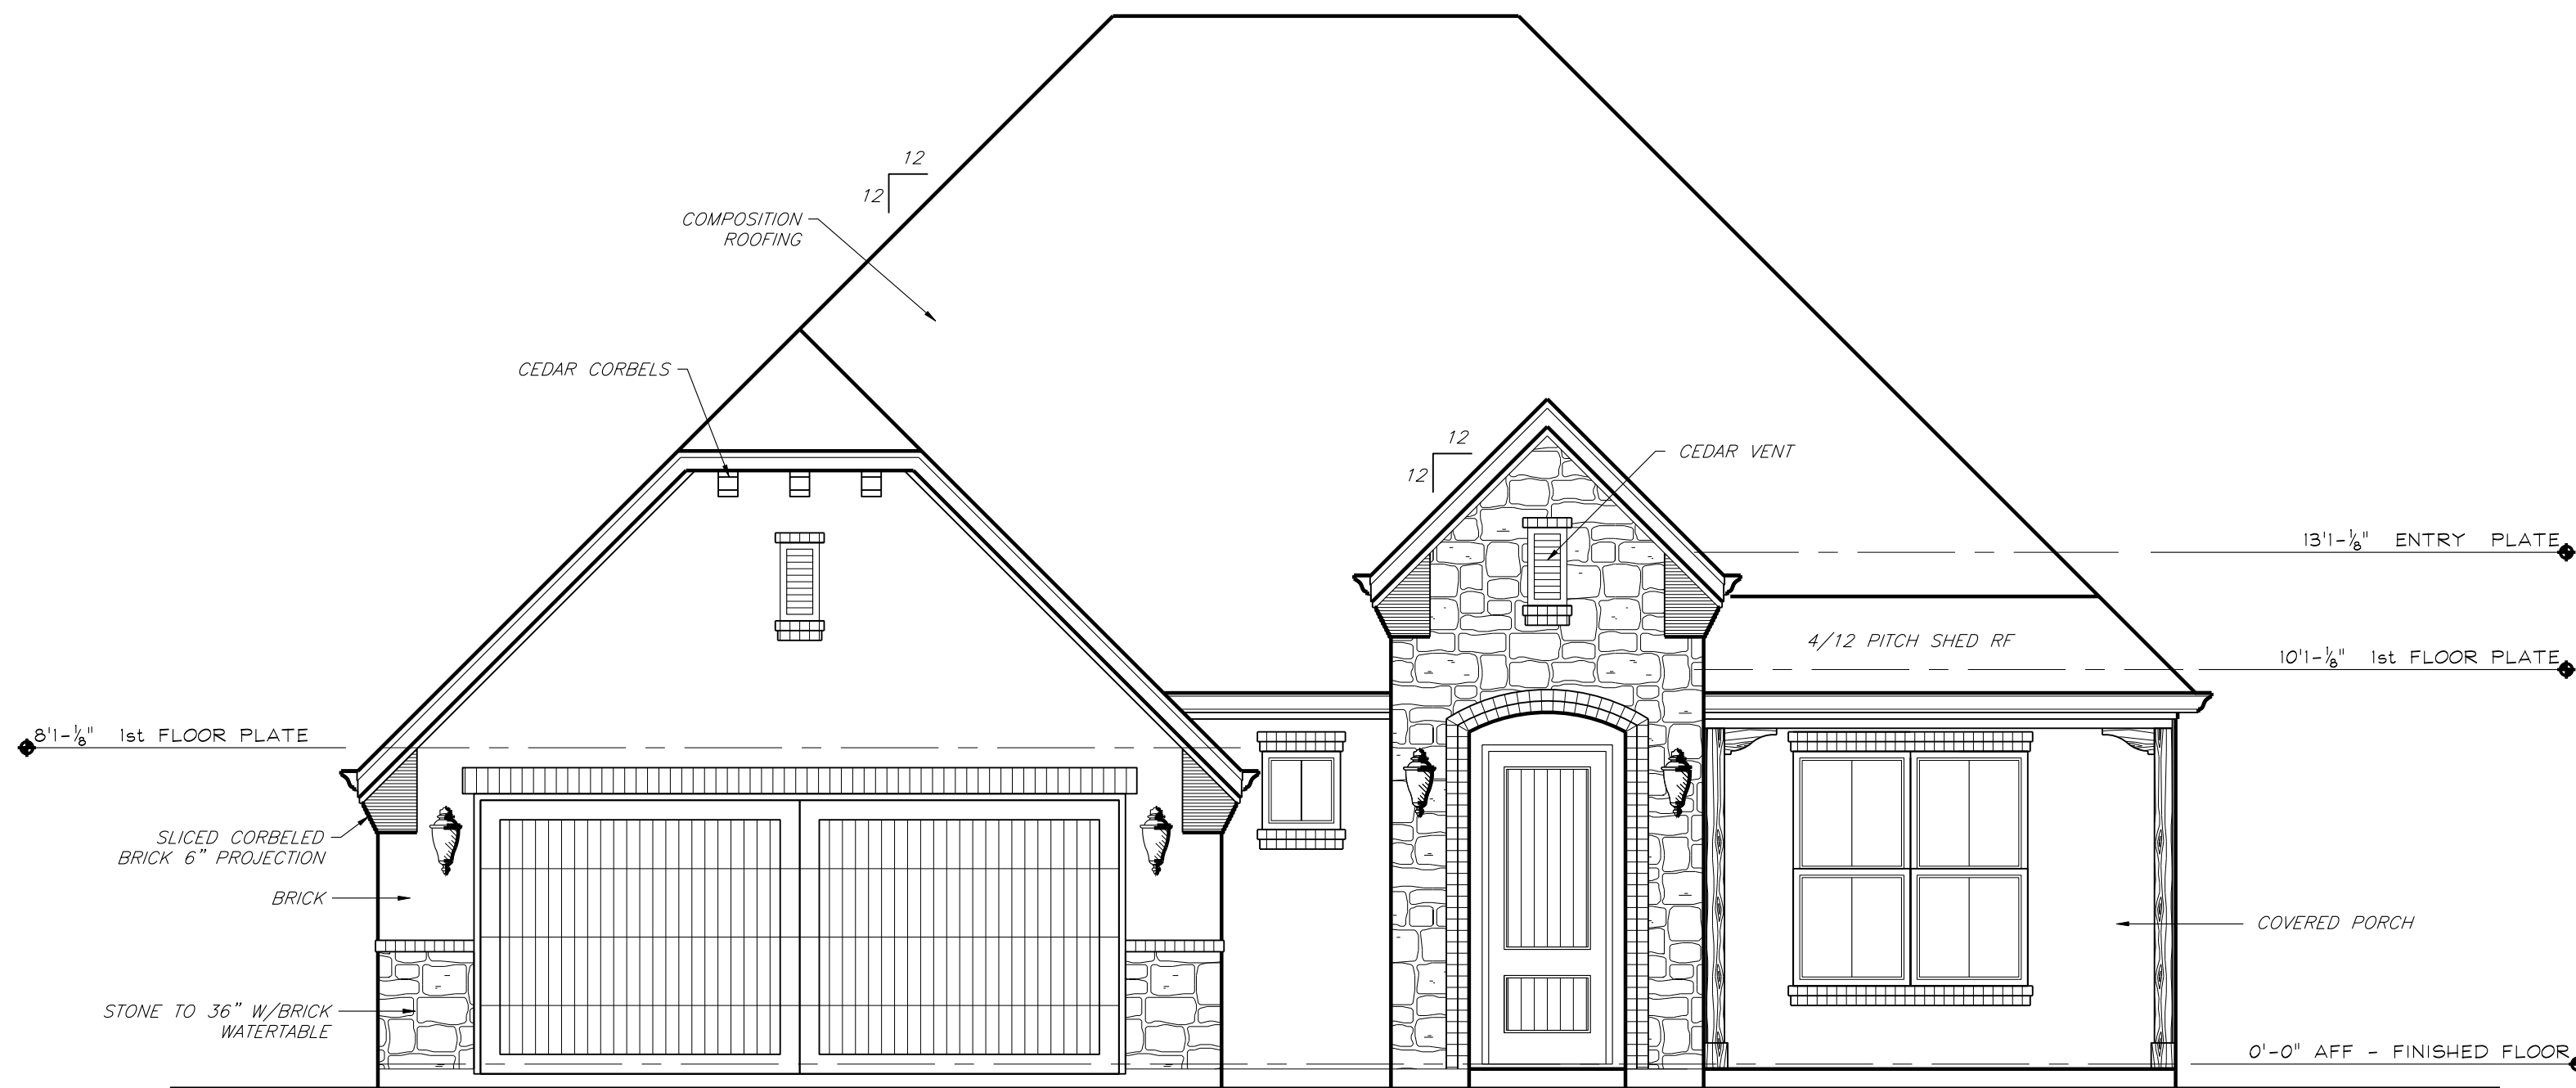


FRONT ELEVATION - B

SCALE: 1" = 1'-0"



FRONT ELEVATION - C


SCALE: 1" = 1'-0"

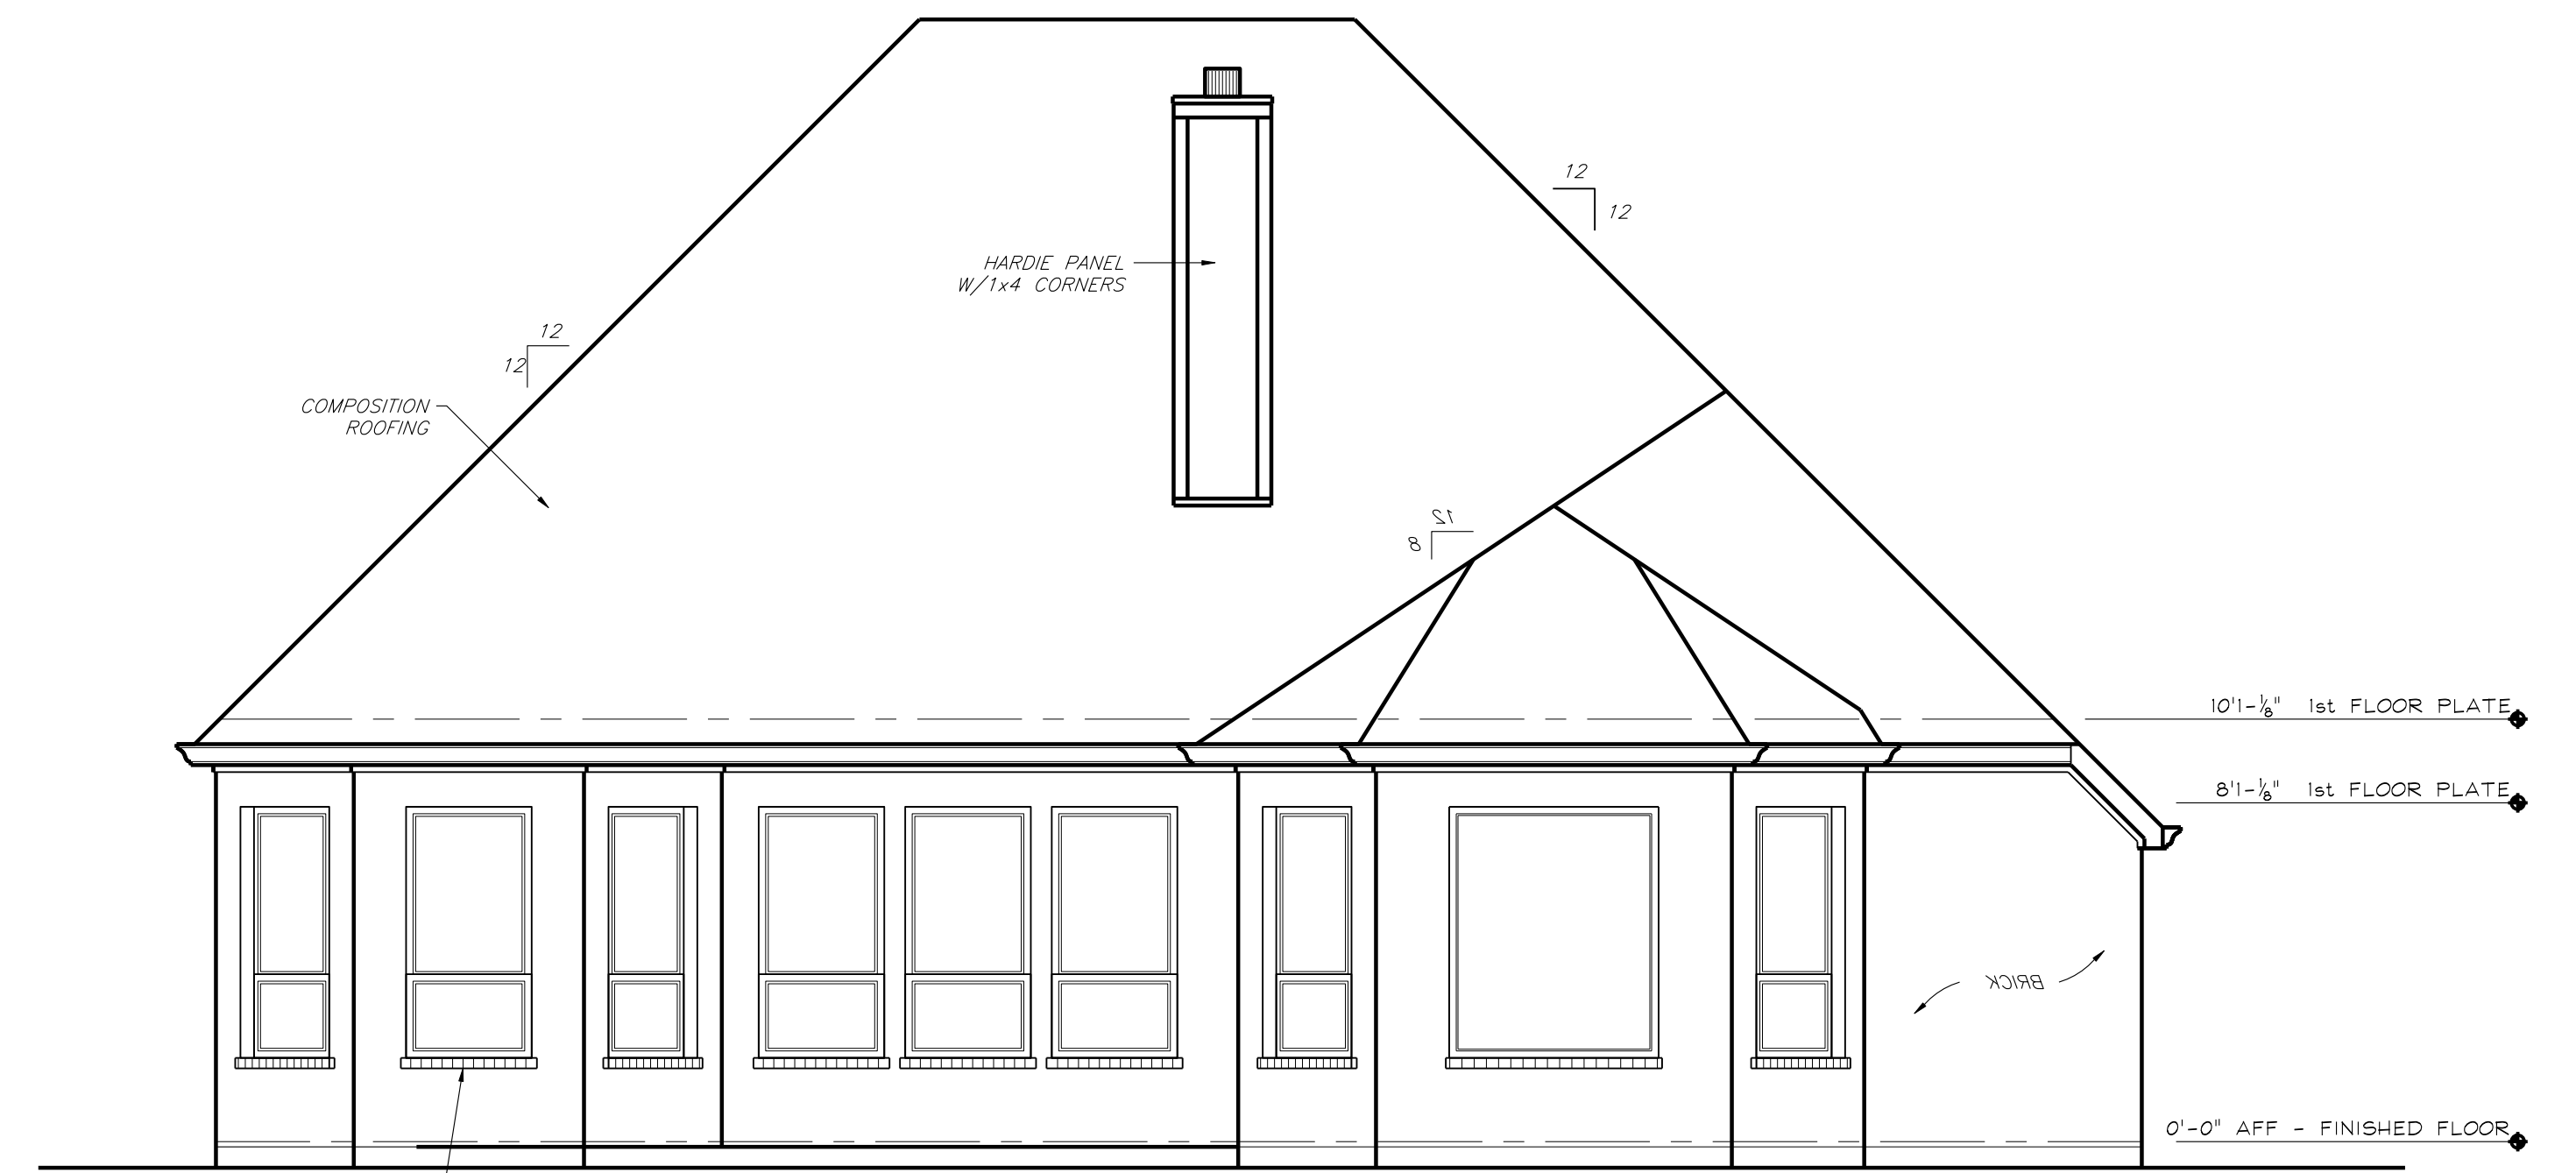

REAR ELEVATION

SCALE: 1" = 1'-0"

#	DESCRIPTION
1	SITE PLAN
2	FOUNDATION PLAN
3	1ST FLOOR PLAN
4	ROOF PLAN
5	FRONT & REAR ELEVATIONS
6	SIDE ELEVATIONS
7	ELECTRICAL PLAN

 

TE: 11.4.16

THESE DRAWINGS, AS INSTRUMENTS OF SERVICE
ARE THE EXCLUSIVE PROPERTY OF THE DESIGNERS,
AND ARE NOT TO BE USED IN WHOLE OR PART
WITHOUT HIS EXPRESS WRITTEN PERMISSION.
UNAUTHORIZED USE OF THESE DRAWINGS WILL
SUBJECT THE USER TO LEGAL REMEDY BEING
SOUGHT BY THE DESIGNERS.

THESE ARCHITECTURAL DRAWINGS HAVE BEEN PREPARED FOR ARCHITECTURAL DESIGN ONLY. CIVIL, STRUCTURAL, MECHANICAL, ELECTRICAL, PLUMBING, AND OTHER RELATED ENGINEERING DESIGN AND SPECIFICATIONS ARE THE RESPONSIBILITY OF THE RESPECTIVE ENGINEERS. COMPLIANCE TO THESE DRAWINGS WILL BE THE RESPONSIBILITY OF THE GENERAL CONTRACTOR. ALL MEASUREMENTS SHALL BE VERIFIED BY THE CONTRACTORS DURING THE RESPECTIVE WORK.

CALEB PLAN - 1 STORY

GRANBURY, TX

RESIDENTIAL
DESIGN STUDIO

3

FLOOR PLAN

FINAL

FOR CONSTRUCTION

