



SHEET INDEX

| # | DESCRIPTION             |
|---|-------------------------|
| 1 | SITE PLAN               |
| 2 | FOUNDATION PLAN         |
| 3 | 1ST FLOOR PLAN          |
| 4 | ROOF PLAN               |
| 5 | FRONT & REAR ELEVATIONS |
| 6 | SIDE ELEVATIONS         |
| 7 | ELECTRICAL PLAN         |

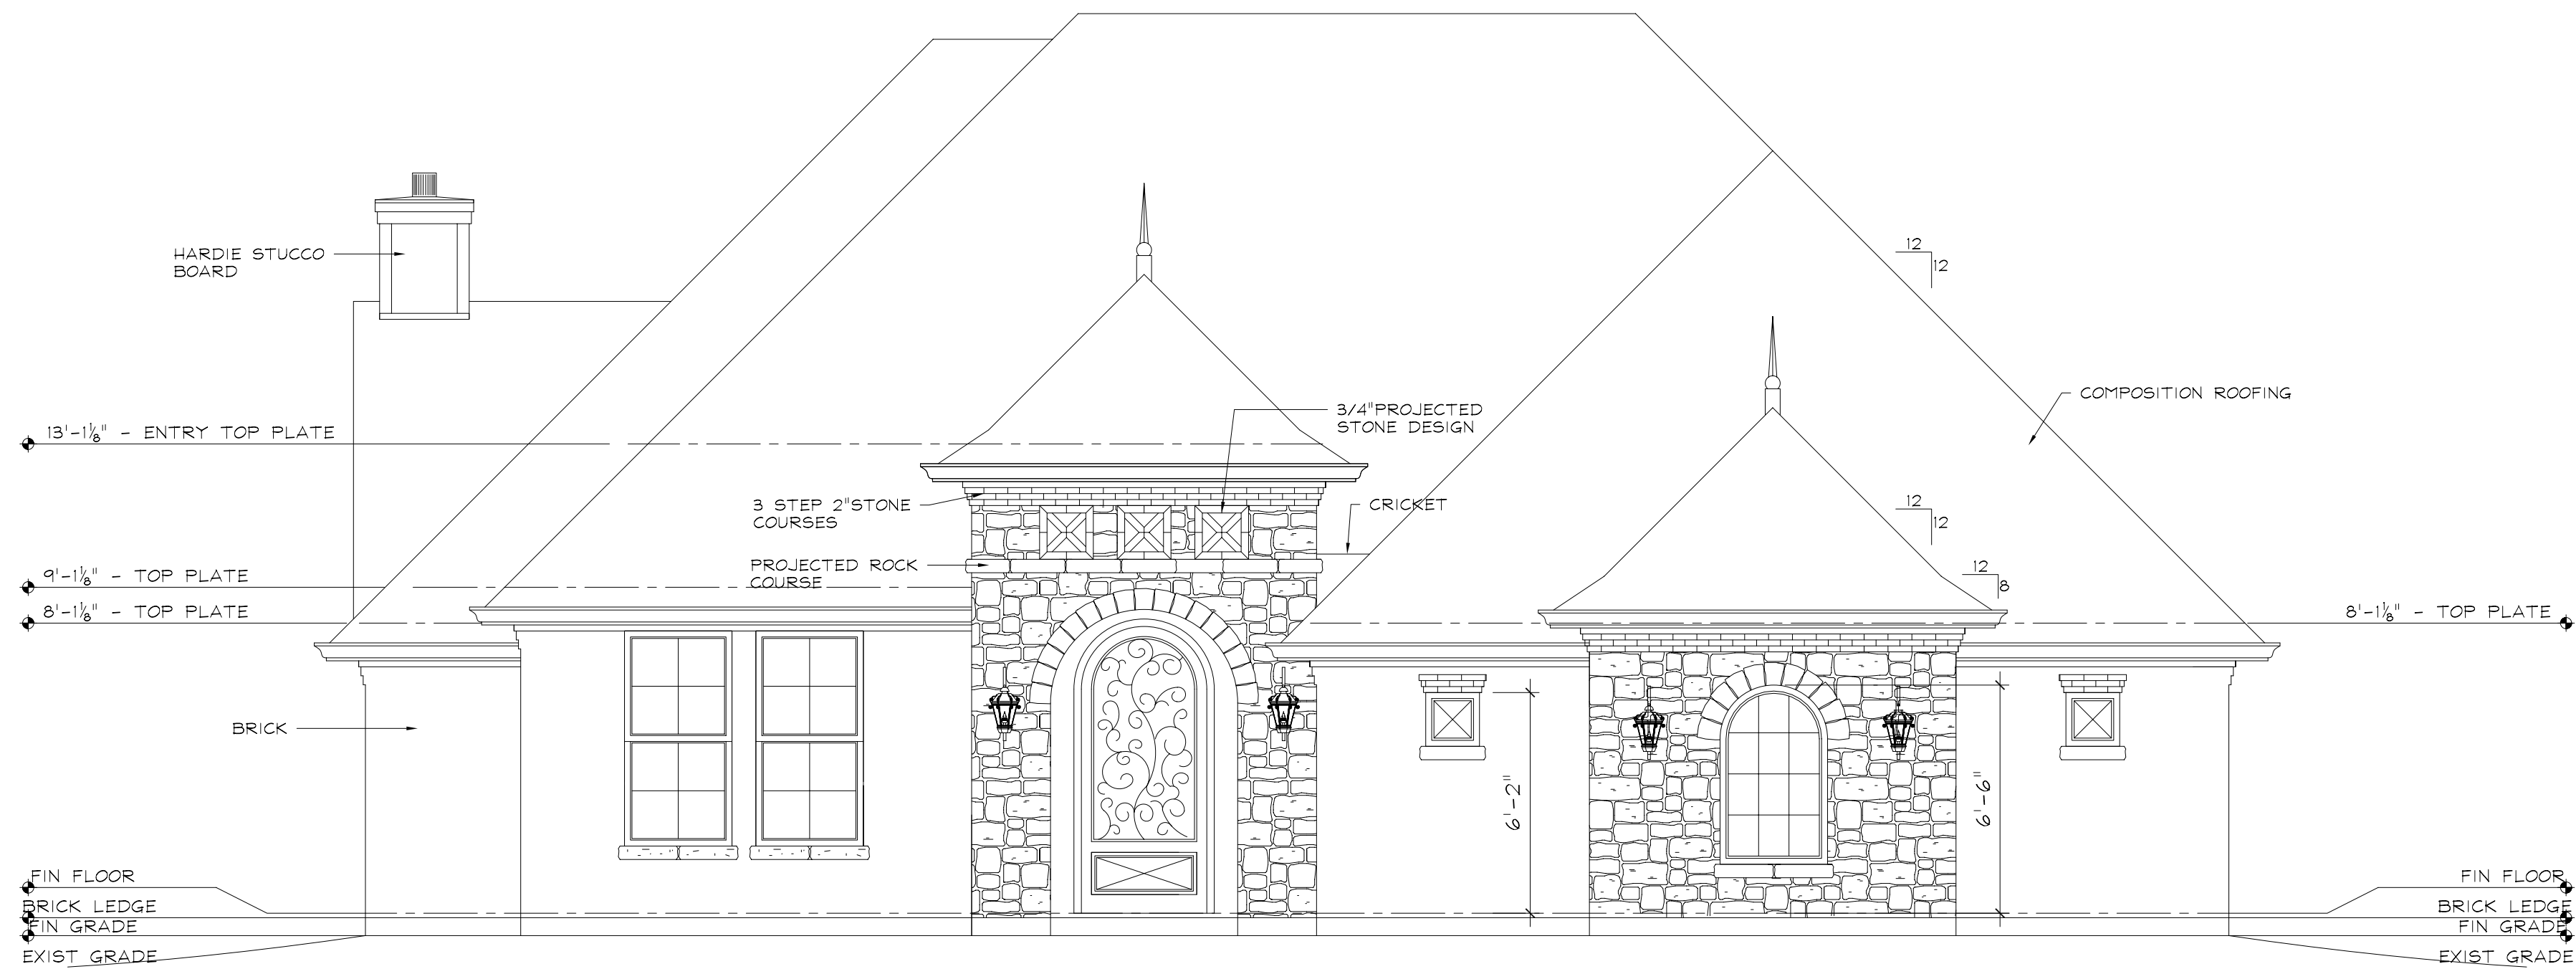

FRONT ELEVATION

SCALE: 1/4" = 1'-0"

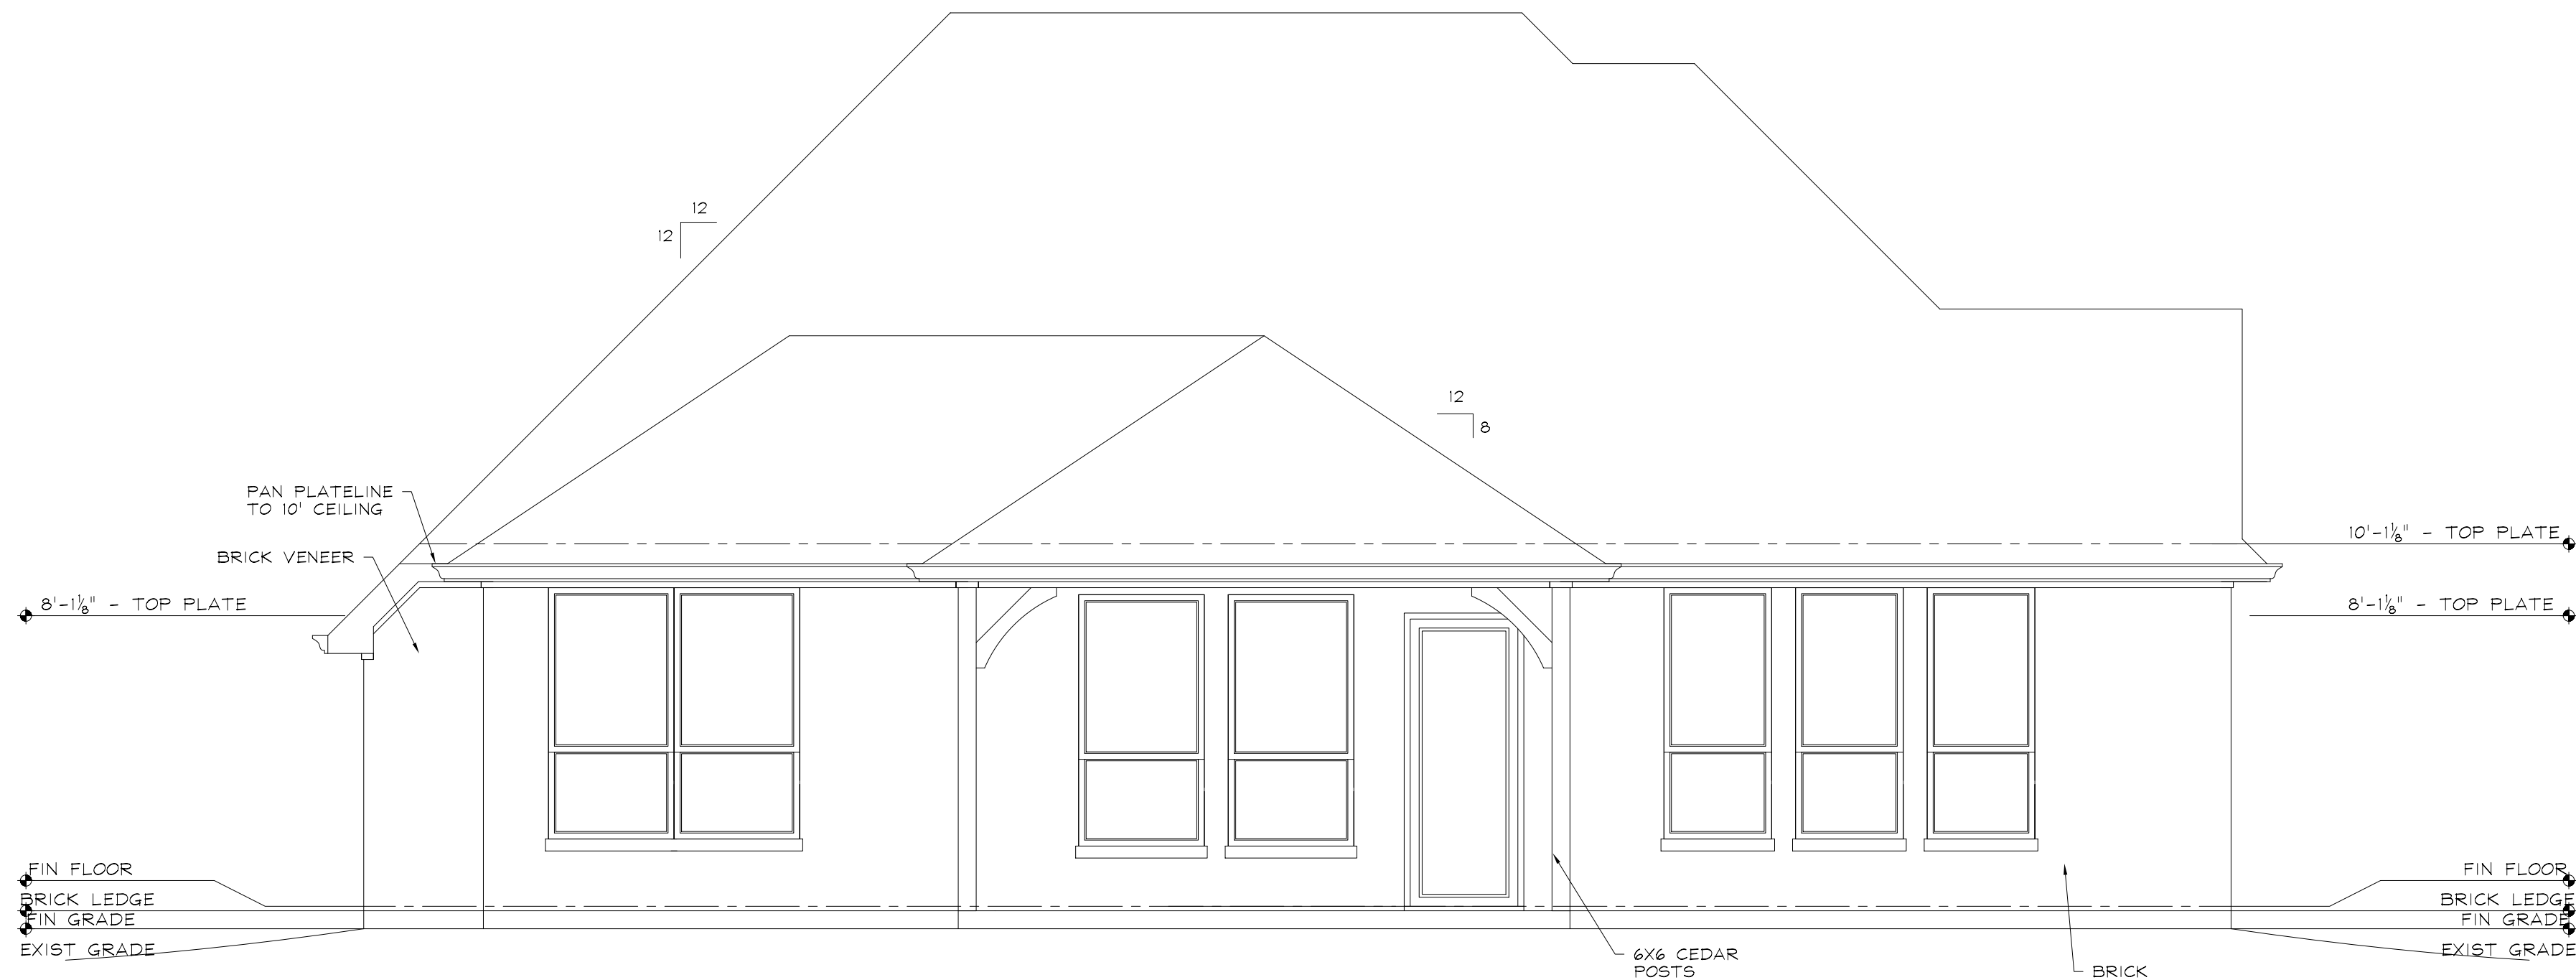

REAR ELEVATION

SCALE: 1/4" = 1'-0"



PLAN # 5555

DATE: 2/4/11

COPYRIGHT 2011 R.D.S.  
THESE DRAWINGS, INSTRUMENTS OF SERVICE, AND ALL RIGHTS THEREIN, ARE THE PROPERTY OF R.D.S. AND ARE NOT TO BE USED IN WHOLE OR PART WITHOUT HIS EXPRESS WRITTEN PERMISSION. ANY REUSE OR REPRODUCTION OF THESE DRAWINGS WITHOUT HIS WRITTEN PERMISSION SHALL BE SUBJECT TO THE USER TO LEGAL ACTION BEING SOUGHT BY THE DESIGNERS.

3208 FALL CREEK HIGHWAY • GRANBURY, TX 76049  
PH: 817-326-2547 FAX: 817-326-2548  
THESE ARCHITECTURAL DRAWINGS HAVE BEEN PREPARED FOR THE ARCHITECT BY R.D.S. IN ACCORDANCE WITH THE PROFESSIONAL SEAL AND OTHER RELATED ENGINEERING DESIGN AND SPECIFICATIONS ARE THE RESPONSIBILITY OF THE RESPECTIVE ENGINEERS. R.D.S. SHALL NOT BE RESPONSIBLE FOR THE ACTIONS OR INACTIONS OF THE GENERAL CONTRACTOR. ALL MEASUREMENTS SHALL BE VERIFIED BY THE CONTRACTORS DOING THE RESPECTIVE WORK.

PROJECT INFORMATION  
J ALLEN HOMES  
CJ WHITACRE  
3229 BOAT LANDING DR  
LOT 41  
GRANBURY, TX

RESIDENTIAL  
DESIGN STUDIO

FINAL  
FOR CONSTRUCTION



FINAL

---

FOR CONSTRUCTION

**RDS**

PLAN # 5555  
DATE: 10-14

COPYRIGHT 2014 R.D.S.  
THESE DRAWINGS, AS INSTRUMENTS OF SERVICE,  
ARE THE EXCLUSIVE PROPERTY OF THE DESIGNERS,  
AND ARE NOT TO BE USED IN WHOLE OR PART  
WITHOUT HIS EXPRESS WRITTEN PERMISSION.  
UNAUTHORIZED USE OF THESE DRAWINGS WILL  
SUBJECT THE USER TO LEGAL REMEDY BEING  
SOUGHT BY THE DESIGNERS.

3208 FALL CREEK HIGHWAY • GRANBURY, TX 76049  
 PHONE: 817-326-2548 FAX: 817-326-2548

THESE ARCHITECTURAL DRAWINGS HAVE BEEN PREPARED FOR  
 ARCHITECTURAL DESIGN ONLY. CIVIL, STRUCTURAL, MECHANICAL,  
 AND OTHER RELATED ENGINEERING DESIGN AND SPECIFICATIONS  
 ARE THE RESPONSIBILITY OF THE RESPECTIVE ENGINEERS.  
 COMPLIANCE TO THESE DRAWINGS WILL BE THE RESPONSIBILITY  
 OF THE GENERAL CONTRACTOR. ALL MEASUREMENTS SHALL BE  
 VERIFIED BY THE CONTRACTORS DURING THE RESPECTIVE WORK.

**PROJECT INFORMATION**

J ALLEN HOMES  
CJ WHITACRE  
3229 BOAT LANDING DR  
LOT 41 PHASE 5A-2  
GRANBURY, TX

**RESIDENTIAL**  
**DESIGN STUDIO**