

SHEET INDEX

#	DESCRIPTION
1	SITE PLAN
2	FOUNDATION PLAN
3	1ST FLOOR PLAN
4	2nd FLOOR PLAN
5	ROOF PLAN
6	FRONT & REAR ELEVATIONS
7	SIDE ELEVATIONS
8	ELECTRICAL PLAN



PLAN # 5555

DATE: 2/4/11


COPYRIGHT 2011 R.D.S.
THESE ARCHITECTURAL DRAWINGS ARE THE PROPERTY OF R.D.S. AND ARE NOT TO BE USED IN WHOLE OR PART WITHOUT HIS EXPRESS WRITTEN PERMISSION. ANY REUSE OR MODIFICATION OF THESE DRAWINGS WITHOUT HIS WRITTEN PERMISSION SHALL BE SUBJECT TO THE USER TO LEGAL REMEDY BEING SOUGHT BY THE DESIGNERS.

3206 FALL CREEK HIGHWAY • GRANBURY, TX 76049
PH: 817-326-2547 FAX: 817-326-2548
THESE ARCHITECTURAL DRAWINGS HAVE BEEN PREPARED FOR LOCAL PERMITTING PURPOSES ONLY. THEY ARE NOT TO BE USED FOR ANY OTHER RELATED ENGINEERING DESIGN AND SPECIFICATIONS ARE THE RESPONSIBILITY OF THE RESPECTIVE ENGINEERS. THE CONTRACTOR SHALL BE RESPONSIBLE FOR VERIFYING THE ACCURACY OF THE GENERAL CONTRACTOR. ALL MEASUREMENTS SHALL BE VERIFIED BY THE CONTRACTORS DURING THE RESPECTIVE WORK.

PROJECT INFORMATION
J. ALLEN HOMES
1506 BOCA BAY CT
GRANBURY, TX

RESIDENTIAL
DESIGN STUDIO

FINAL
FOR CONSTRUCTION

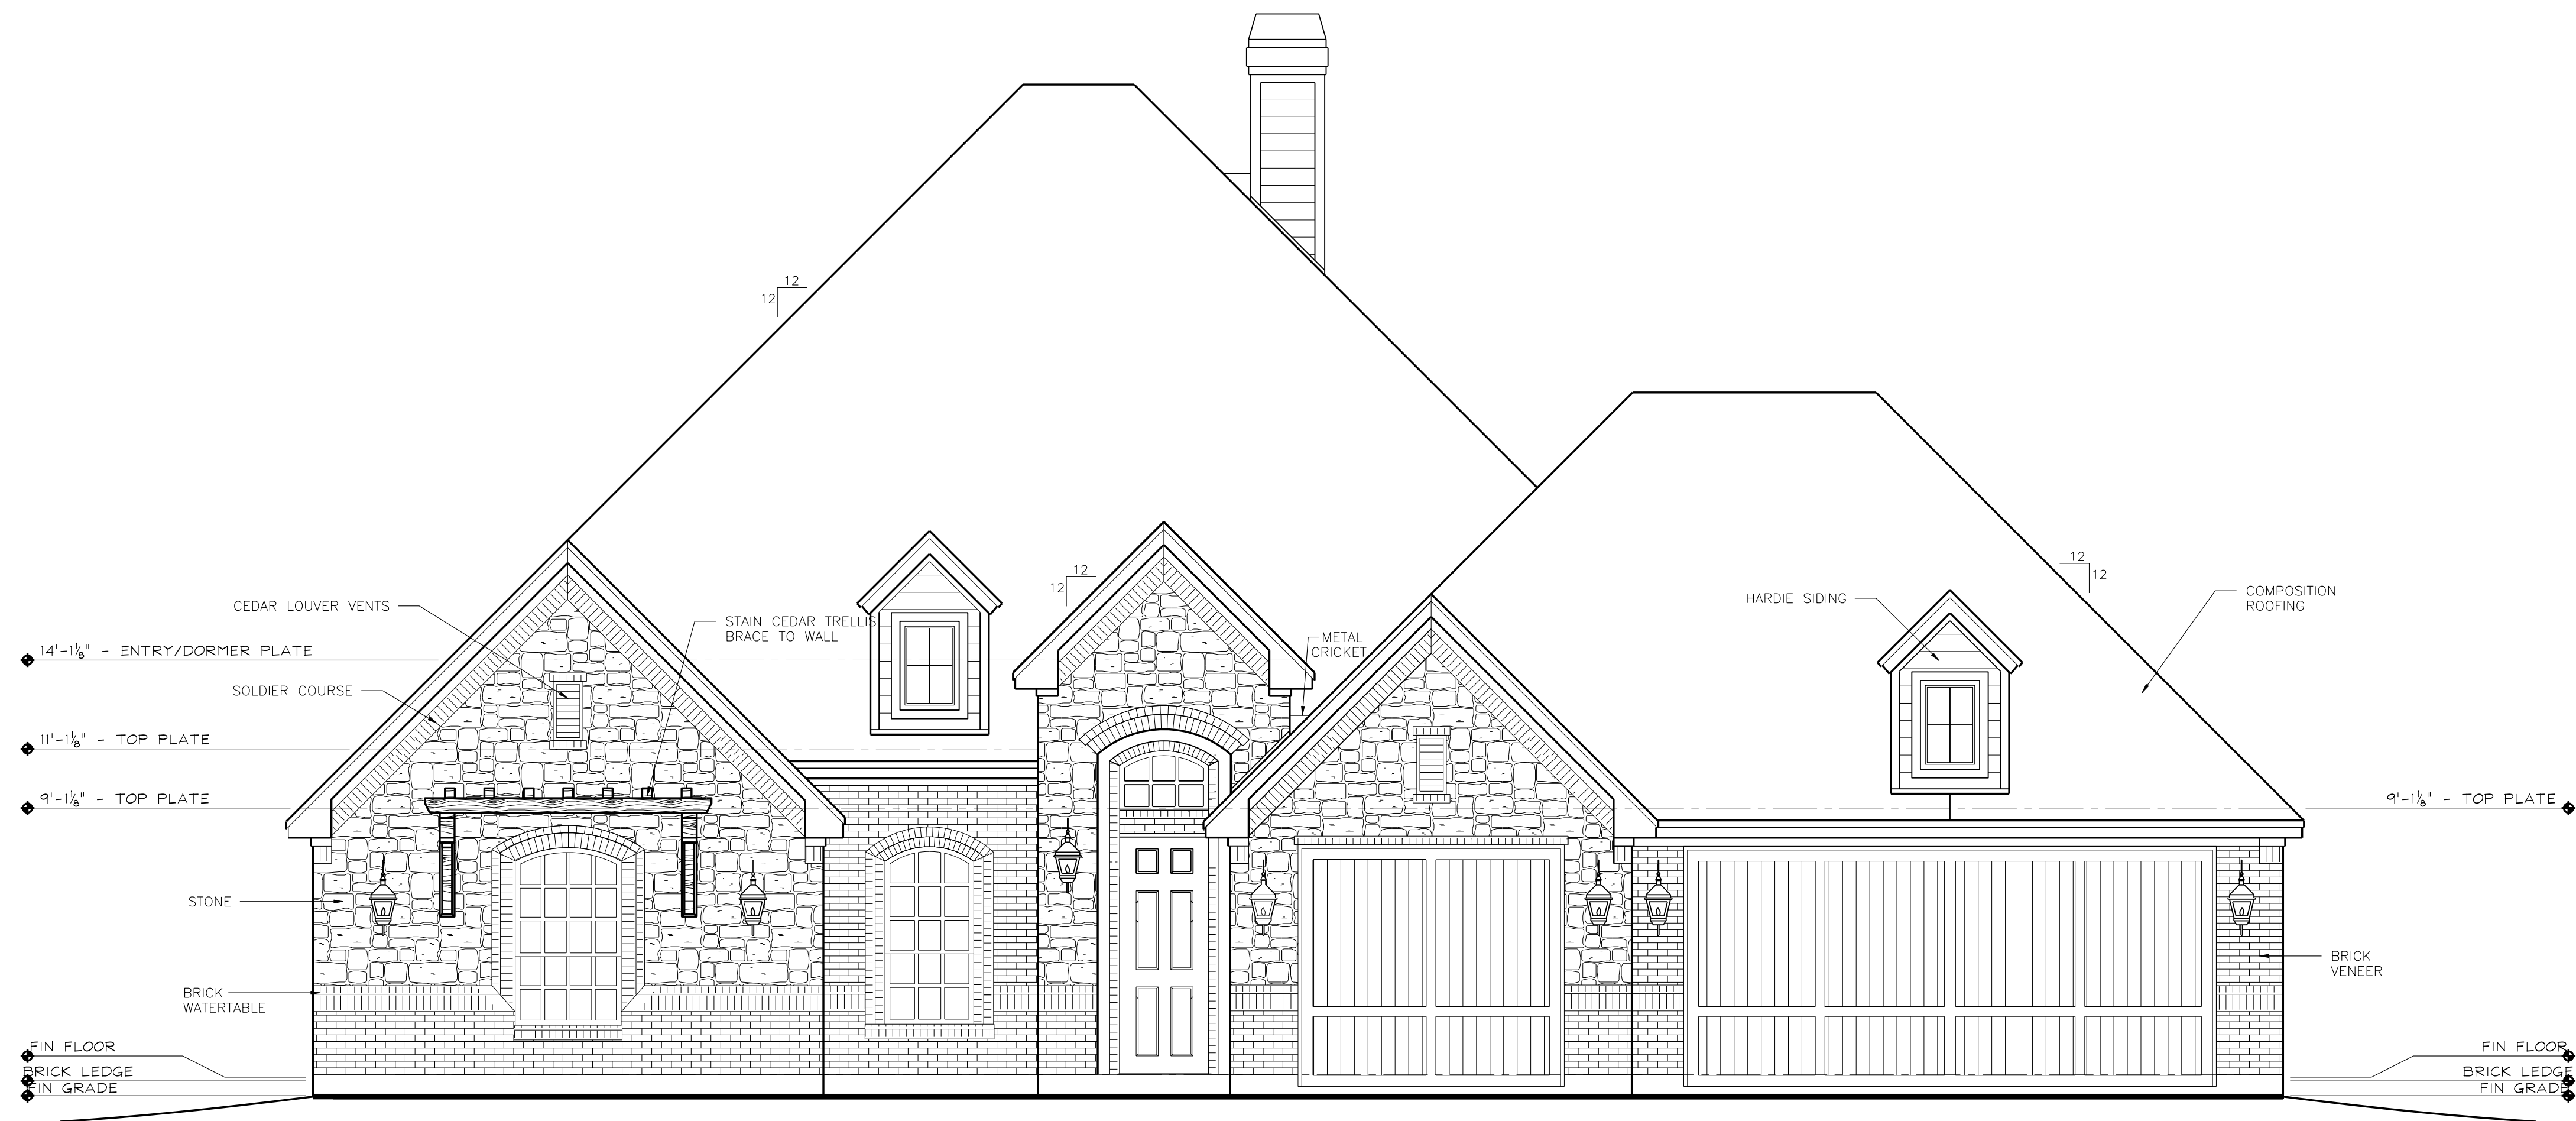


FRONT ELEVATION

SCALE: 1" = 1'-0"



REAR ELEVATION

SCALE: 1" = 1'-0"

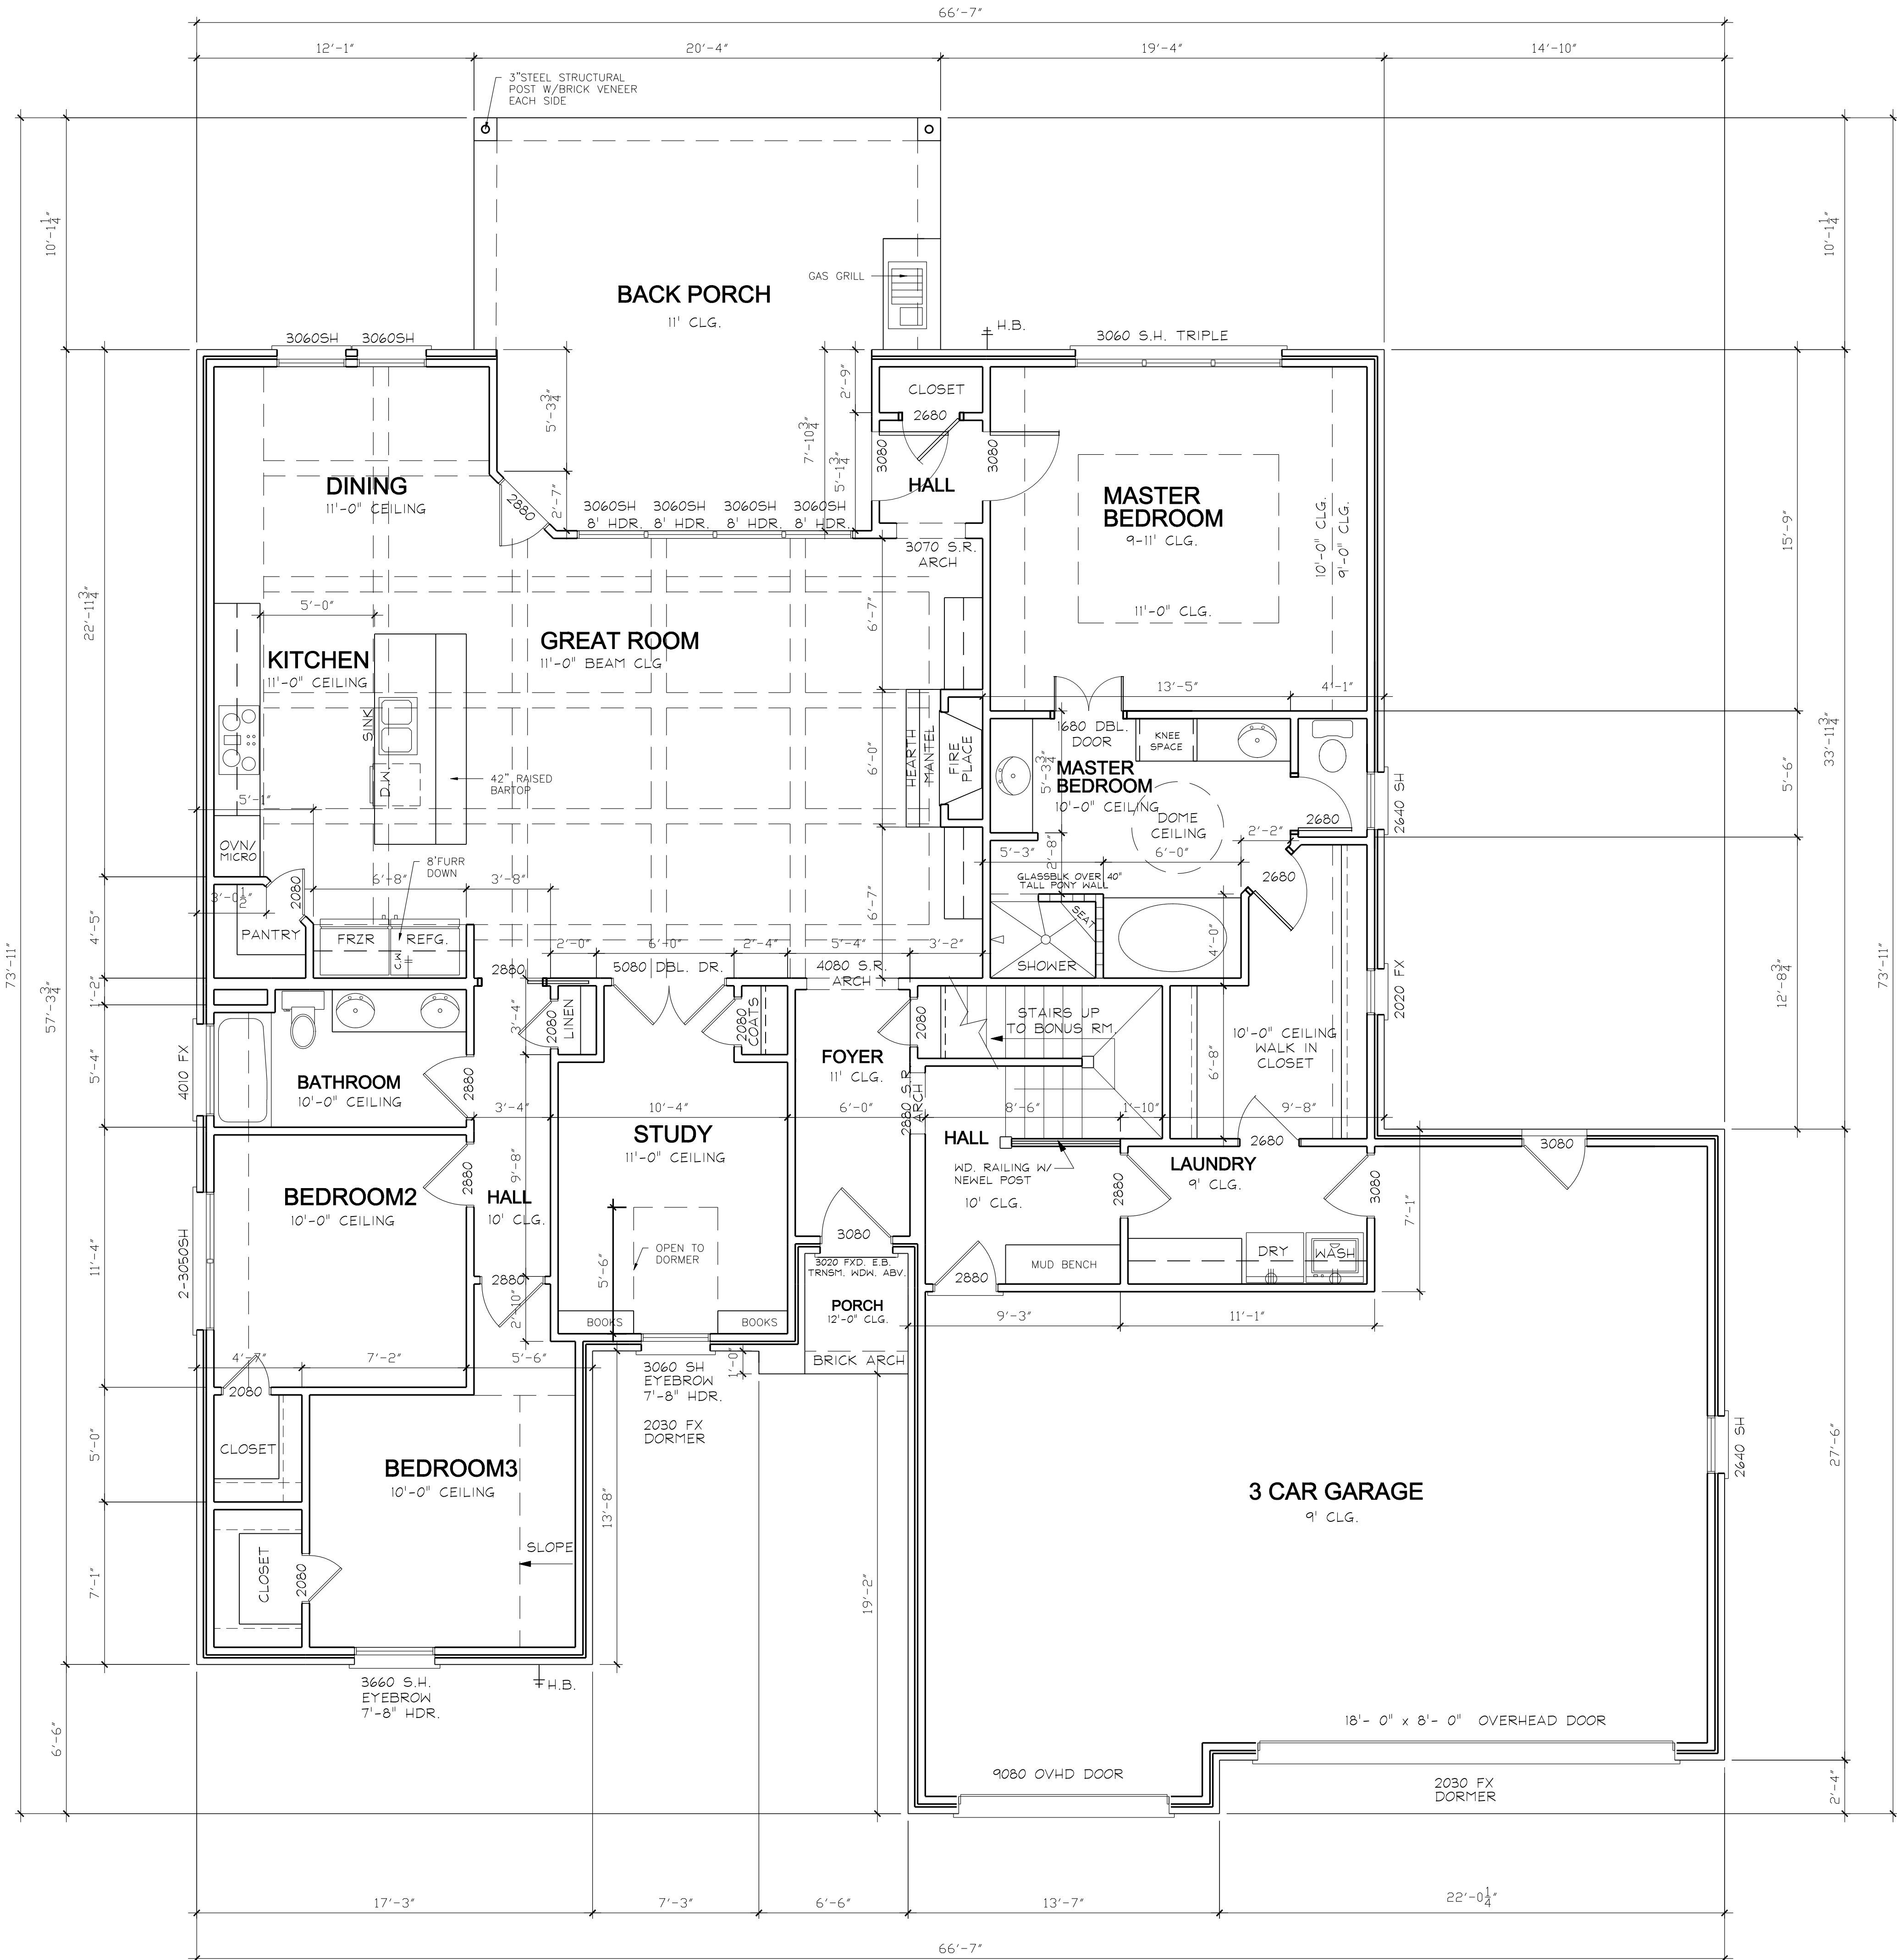

FLOORPLAN
1/4"=1'-0"

SHEET INDEX

#	DESCRIPTION
1	SITE PLAN
2	FOUNDATION PLAN
3	1ST FLOOR PLAN
4	2nd FLOOR PLAN
5	ROOF PLAN
6	FRONT & REAR ELEVATIONS
7	SIDE ELEVATIONS
8	ELECTRICAL PLAN



PLAN # 5555
DATE: 2/4/11

COPYRIGHT 2011 R.D.S.
THESE DRAWINGS, INSTRUMENTS OF SERVICE, AND ALL RIGHTS RESERVED BY THE DESIGNERS, ARE NOT TO BE USED IN WHOLE OR PART WITHOUT HIS EXPRESS WRITTEN PERMISSION. ANY REUSE OR MODIFICATION OF THESE DRAWINGS WITHOUT THE USER TO LEGAL REMEDY BEING SOUGHT BY THE DESIGNERS.

3206 FALL CREEK HIGHWAY • GRANBURY, TX 76049
PH: 817-326-2547 FAX: 817-326-2548
THESE ARCHITECTURAL DRAWINGS HAVE BEEN PREPARED FOR THE CLIENT BY THE DESIGNERS, AND THE DESIGNERS ARE NOT RESPONSIBLE FOR THE ACCURACY OF THE INFORMATION PROVIDED BY THE CLIENT. THE DESIGNERS ARE THE RESPONSIBILITY OF THE RESPECTIVE ENGINEERS, ARCHITECTS, AND OTHER PROFESSIONALS. ALL MEASUREMENTS SHALL BE VERIFIED BY THE CONTRACTORS DURING THE RESPECTIVE WORK.

PROJECT INFORMATION
J. ALLEN HOMES
1506 BOCA BAY CT
THE ISLAND
GRANBURY, TX

RESIDENTIAL
DESIGN STUDIO

SQUARE FOOTAGE
MAIN FLOOR - 2293
UPPER FLOOR - 481
TOTAL LIVING - 2774
FRONT PORCH - 26
BACK PORCH - 331
GARAGE - 866
TOTAL UNDER ROOF - 3997

FINAL
FOR CONSTRUCTION

SHEET INDEX

#	DESCRIPTION
1	SITE PLAN
2	FOUNDATION PLAN
3	1ST FLOOR PLAN
4	2nd FLOOR PLAN
5	ROOF PLAN
6	FRONT & REAR ELEVATIONS
7	SIDE ELEVATIONS
8	ELECTRICAL PLAN



PLAN # 5555

DATE: 2/4/11

COPYRIGHT 2011 R.D.S.
THESE DRAWINGS, INSTRUMENTS OF SERVICE
AND ALL RIGHTS RESERVED ARE THE PROPERTY OF
R.D.S. AND ARE NOT TO BE USED IN WHOLE OR PART
WITHOUT HIS EXPRESS WRITTEN PERMISSION.
THESE DRAWINGS SHALL BE KEPT IN THE ORIGINAL
FORM AND NOT REPRODUCED OR TRANSMITTED IN ANY
MANNER, ELECTRONIC OR MECHANICAL, INCLUDING
PHOTOCOPYING, RECORDING, OR BY ANY INFORMATION
SYSTEM, WITHOUT THE WRITTEN PERMISSION OF
R.D.S. THE USER SHALL BE SOUGHT BY THE DESIGNERS.


3206 FALL CREEK HIGHWAY • GRANBURY, TX 76049
PH: 817-326-2547 FAX: 817-326-2548
THESE ARCHITECTURAL DRAWINGS HAVE BEEN PREPARED FOR
THE PROJECT DESCRIBED HEREIN AND FOR THE SPECIFIC
AND OTHER RELATED ENGINEERING DESIGN AND SPECIFICATIONS
ARE THE RESPONSIBILITY OF THE RESPECTIVE ENGINEERS.
THESE DRAWINGS SHALL BE KEPT IN THE ORIGINAL
FORM AND NOT REPRODUCED OR TRANSMITTED IN ANY
MANNER, ELECTRONIC OR MECHANICAL, INCLUDING
PHOTOCOPYING, RECORDING, OR BY ANY INFORMATION
SYSTEM, WITHOUT THE WRITTEN PERMISSION OF
R.D.S. THE USER SHALL BE SOUGHT BY THE DESIGNERS.

PROJECT INFORMATION
J ALLEN HOMES
1506 BOCA BAY CT
GRANBURY, TX

RESIDENTIAL
DESIGN STUDIO

FINAL
FOR CONSTRUCTION

4

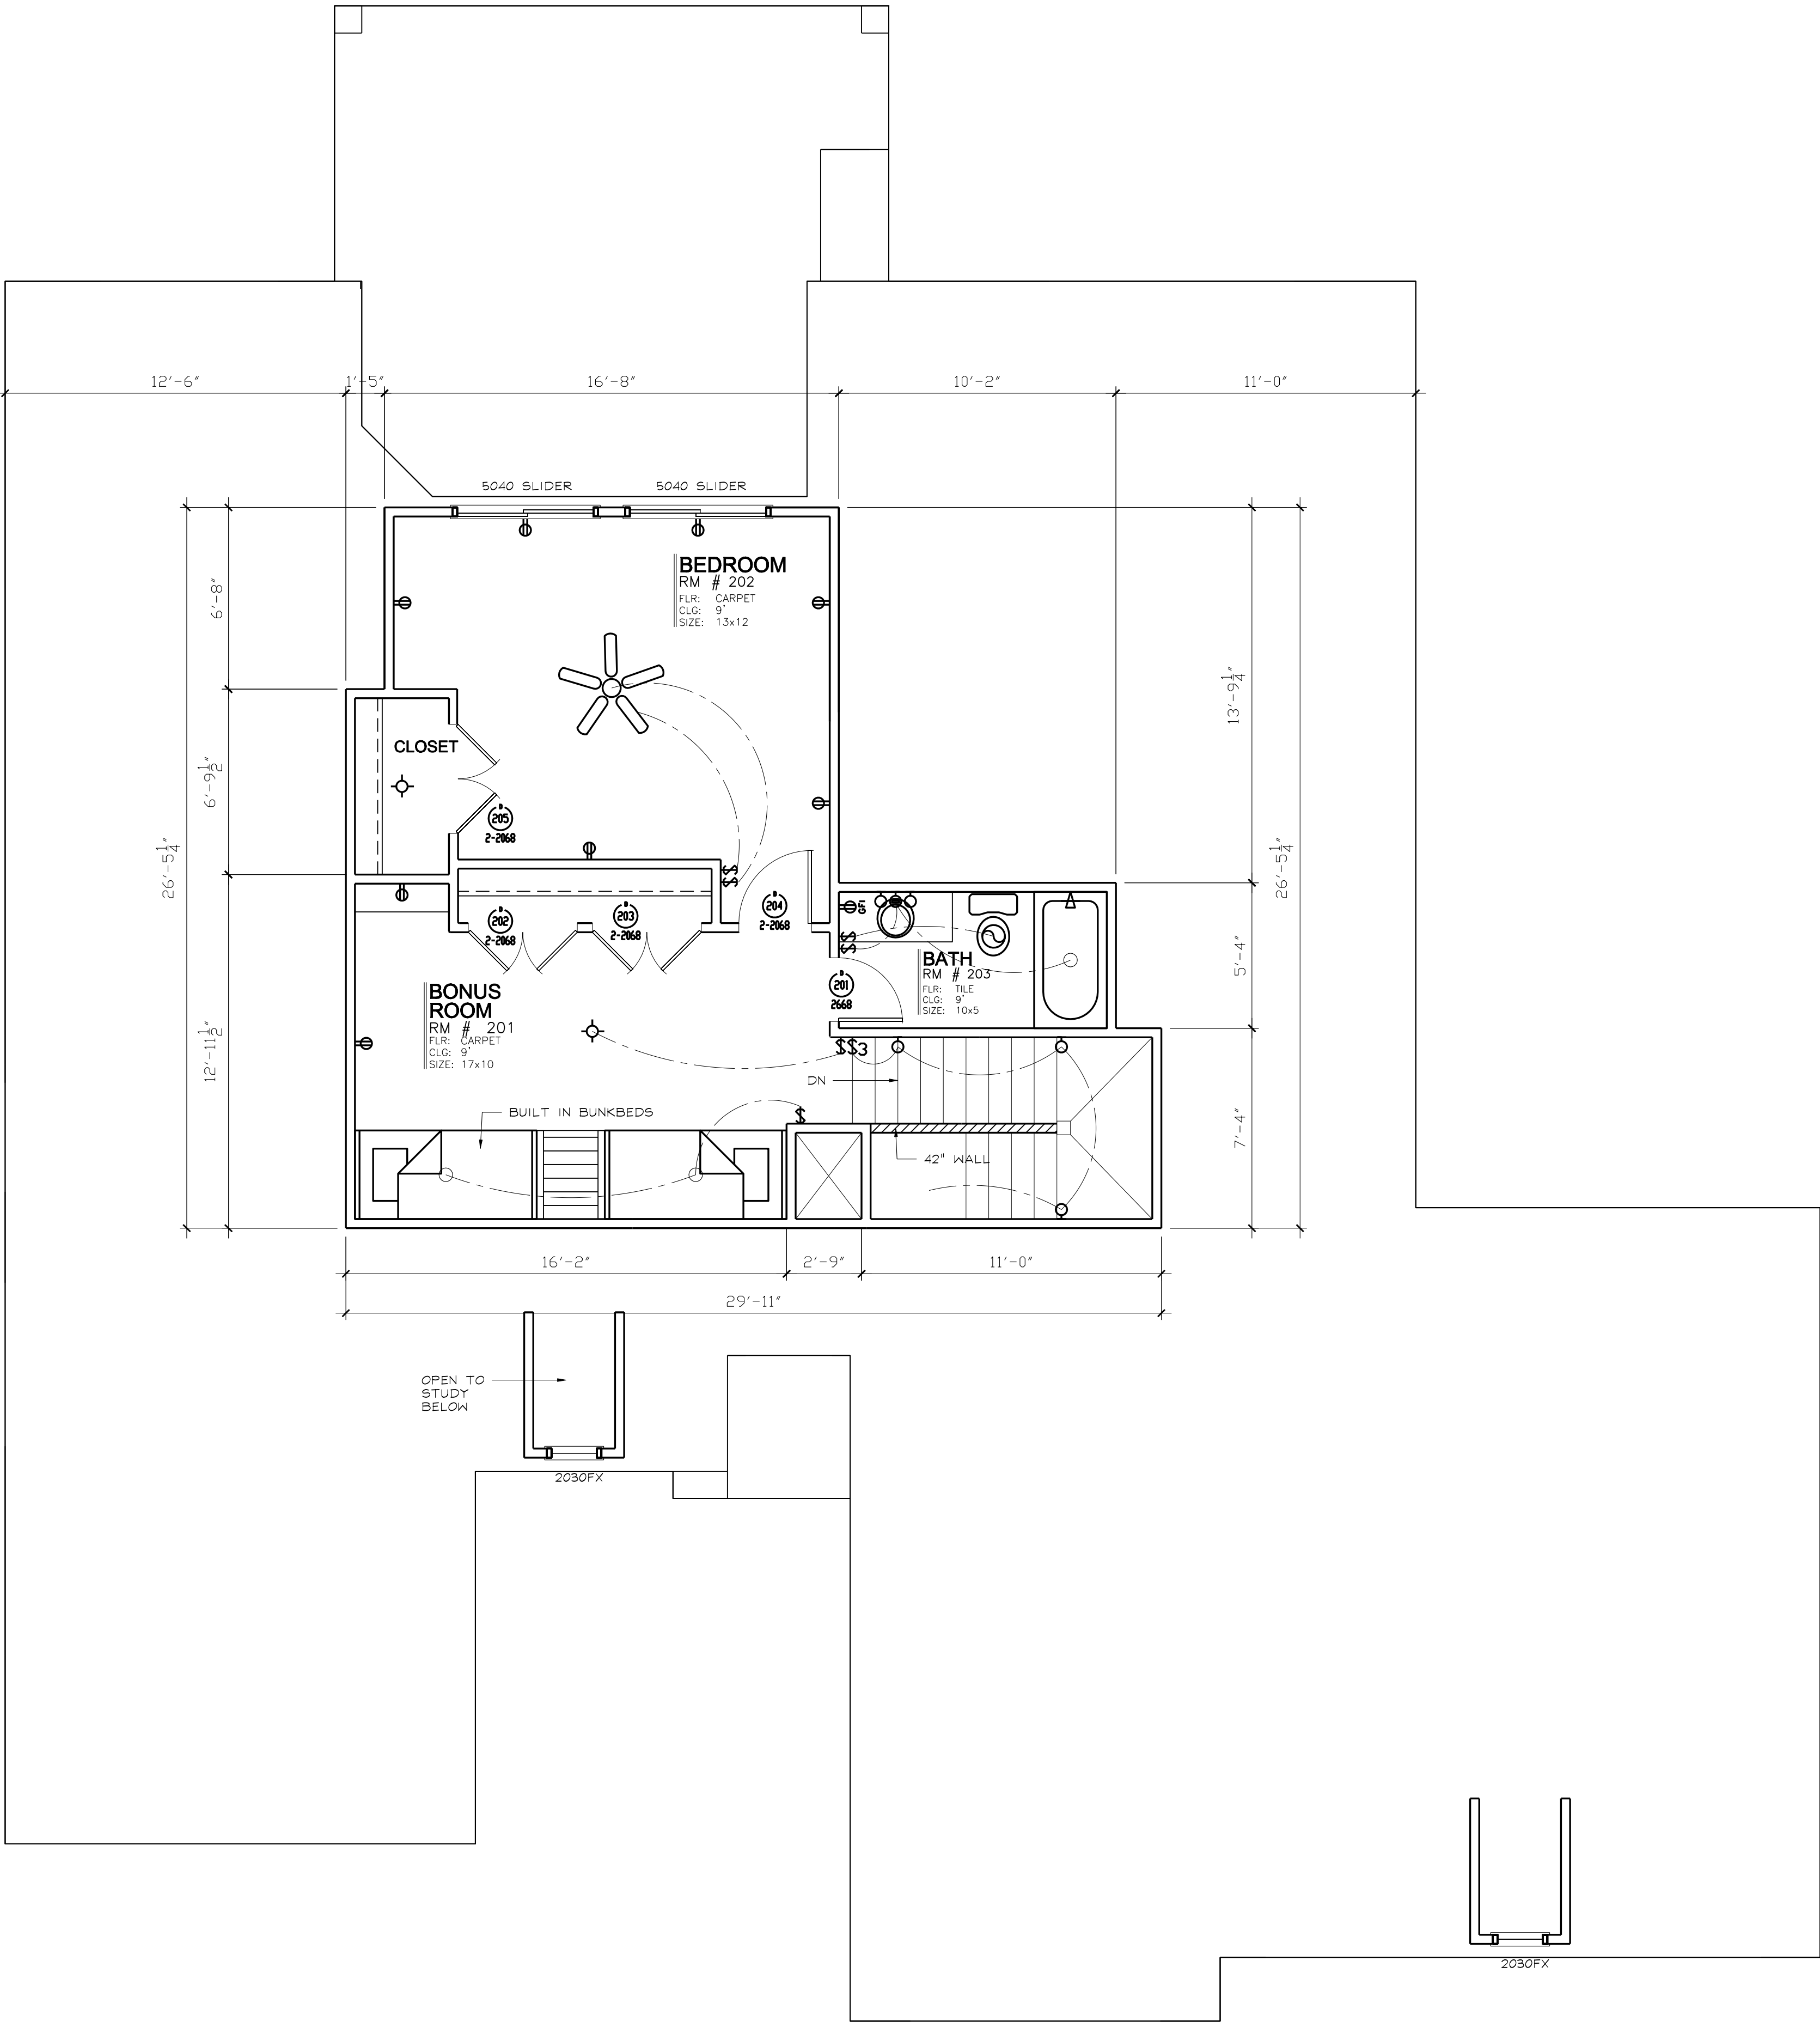

SECOND FLOOR PLAN

SCALE: 1/4"=1'-0"