

FRONT ELEVATION
1/4"=1'-0"

DESIGNED BY:		
DRAWN BY:		
DATE PLOTTED:		
ISSUE FOR PRICING / BIDDING:		
ISSUE FOR PERMIT APPLICATION:		
ISSUE FOR CONSTRUCTION:		
REVISIONS:		
#	DATE	COMMENTS

3206 FALL CREEK HIGHWAY • GRANBURY, TX 76049
PH: 817-326-2547 FAX: 817-326-2548
THESE DRAWINGS ARE PREPARED FOR THE ARCHITECTURAL DESIGN ONLY. CIVIL, STRUCTURAL, MECHANICAL, AND OTHER RELATED ENGINEERING DESIGN AND SPECIFICATIONS ARE THE RESPONSIBILITY OF THE RESPECTIVE ENGINEERS. THE CONTRACTOR SHALL BE RESPONSIBLE FOR VERIFYING ALL MEASUREMENTS SHALL BE VERIFIED BY THE CONTRACTORS DOING THE RESPECTIVE WORK.

J ALLEN HOMES


COPYRIGHT © 2019
THESE DRAWINGS, AS INSTRUMENTS OF SERVICE, ARE THE PROPERTY OF J ALLEN HOMES. NO PART OF THESE DRAWINGS MAY BE REPRODUCED OR TRANSMITTED IN ANY FORM OR BY ANY MEANS, ELECTRONIC OR MECHANICAL, WITHOUT THE WRITTEN PERMISSION OF J ALLEN HOMES. REMEDY BEING LIMITED TO THE RESCINDING OF THESE DRAWINGS.

CATHERINE PLAN – 2 STORY

GRANBURY, TX

SHEET CONTENTS:	
FRONT Elevation	
SHEET NO.	
A6	
August 29, 2019	

SQUARE FOOTAGE	
FIRST FLOOR AC:	1964
SECOND FLOOR AC:	839
TOTAL LIVING:	2803
FRONT PORCH	52.8
BACK PORCH	138
GARAGE	487
TOTAL	3481

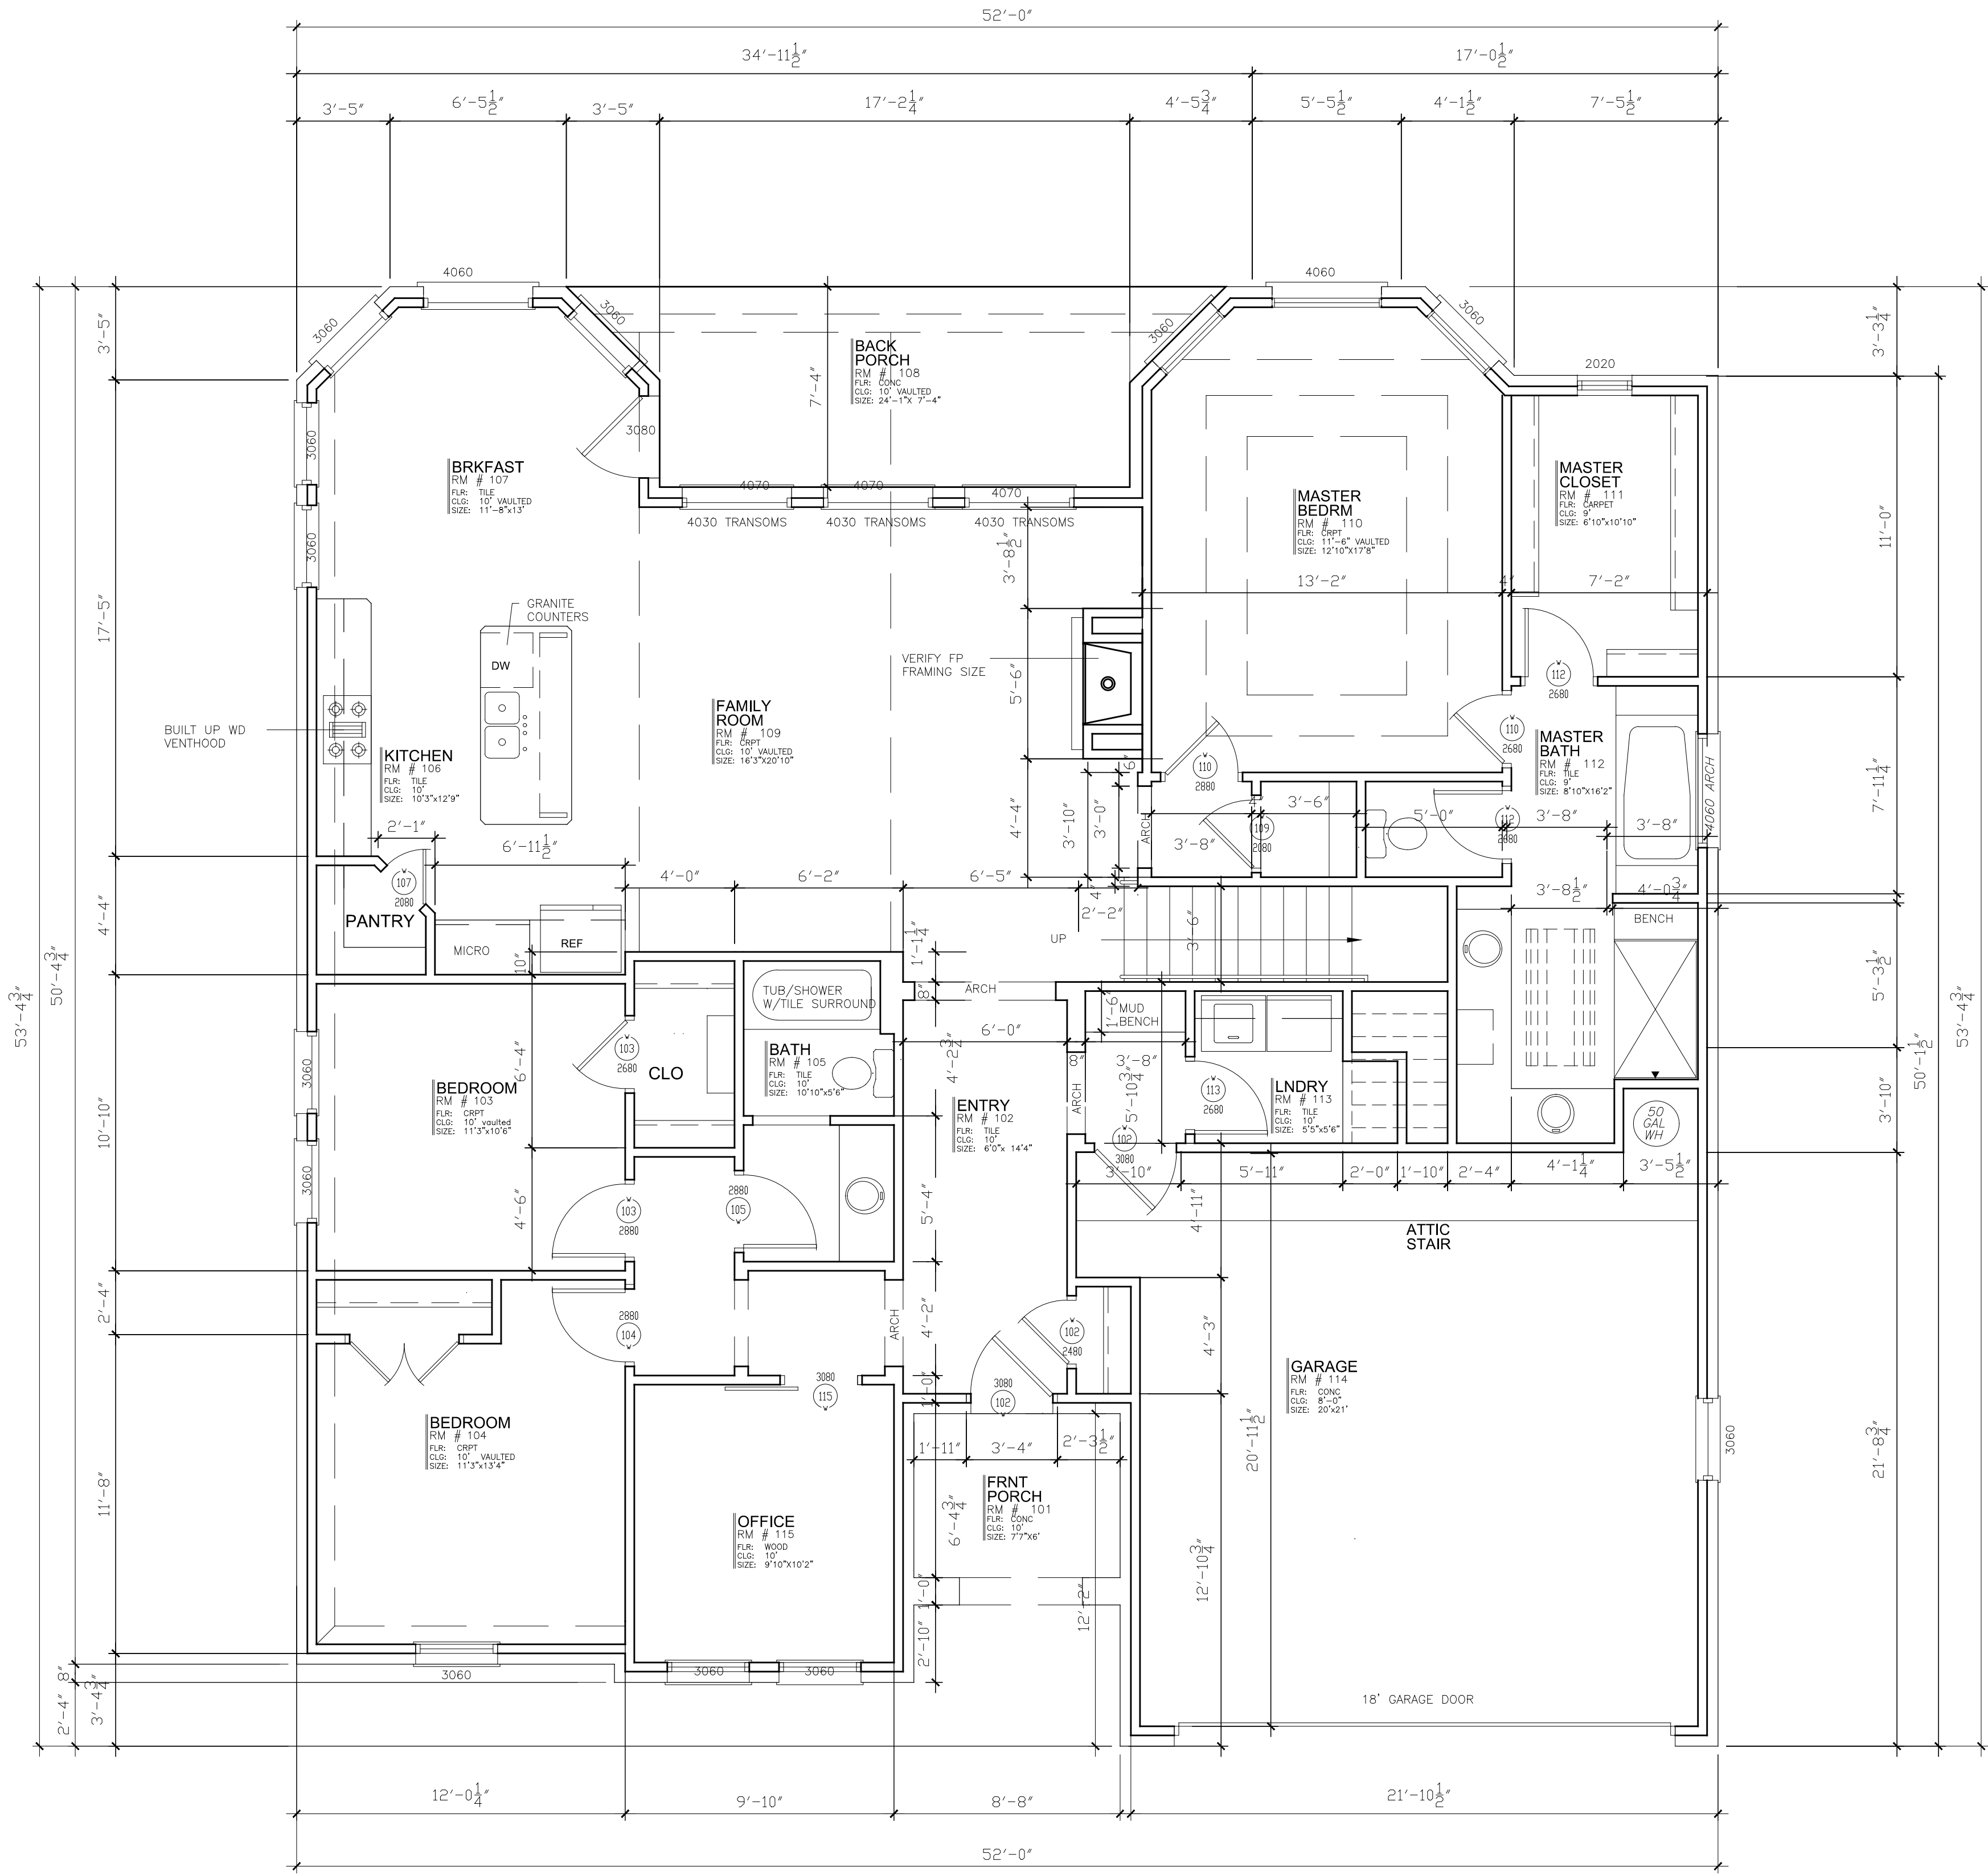

1ST FLOOR PLAN

1/4"=1'-0"

1,964 S.F.AC

DESIGNED BY:		
DRAWN BY:		
DATE PLOTTED:		
ISSUE FOR PRICING / BIDDING:		
ISSUE FOR PERMIT APPLICATION:		
ISSUE FOR CONSTRUCTION:		
REVISIONS:		
#	DATE	COMMENTS

3206 FALL CREEK HIGHWAY • GRANBURY, TX 76049

THESE ARCHITECTURAL DRAWINGS HAVE BEEN PREPARED FOR ARCHITECTURAL DESIGN ONLY. CIVIL, STRUCTURAL, MECHANICAL, AND OTHER RELATED ENGINEERING DESIGN AND SPECIFICATIONS ARE THE RESPONSIBILITY OF THE ENGINEER. THE ARCHITECT ASSURES COMPLIANCE TO THESE DRAWINGS WILL BE THE RESPONSIBILITY OF THE GENERAL CONTRACTOR. ALL MEASUREMENTS SHALL BE VERIFIED BY THE CONTRACTORS DURING THE RESPECTIVE WORK.

J ALLEN HOMES

COPYRIGHT © 2019

THESE DRAWINGS, AS INSTRUMENTS OF SERVICE, ARE THE PROPERTY OF J ALLEN HOMES, INC. AND ARE NOT TO BE USED IN WHOLE OR PART FOR ANY OTHER PROJECT WITHOUT THE WRITTEN AUTHORIZATION OF J ALLEN HOMES, INC. UNAUTHORIZED USE OF THESE DRAWINGS WILL BE SOUGHT BY THE DESIGNATOR.

CATHERINE PLAN - 2 STORY

GRANBURY, TX


SHEET CONTENTS:

GROUND FLOOR

SHEET NO.

A2

August 29, 2019

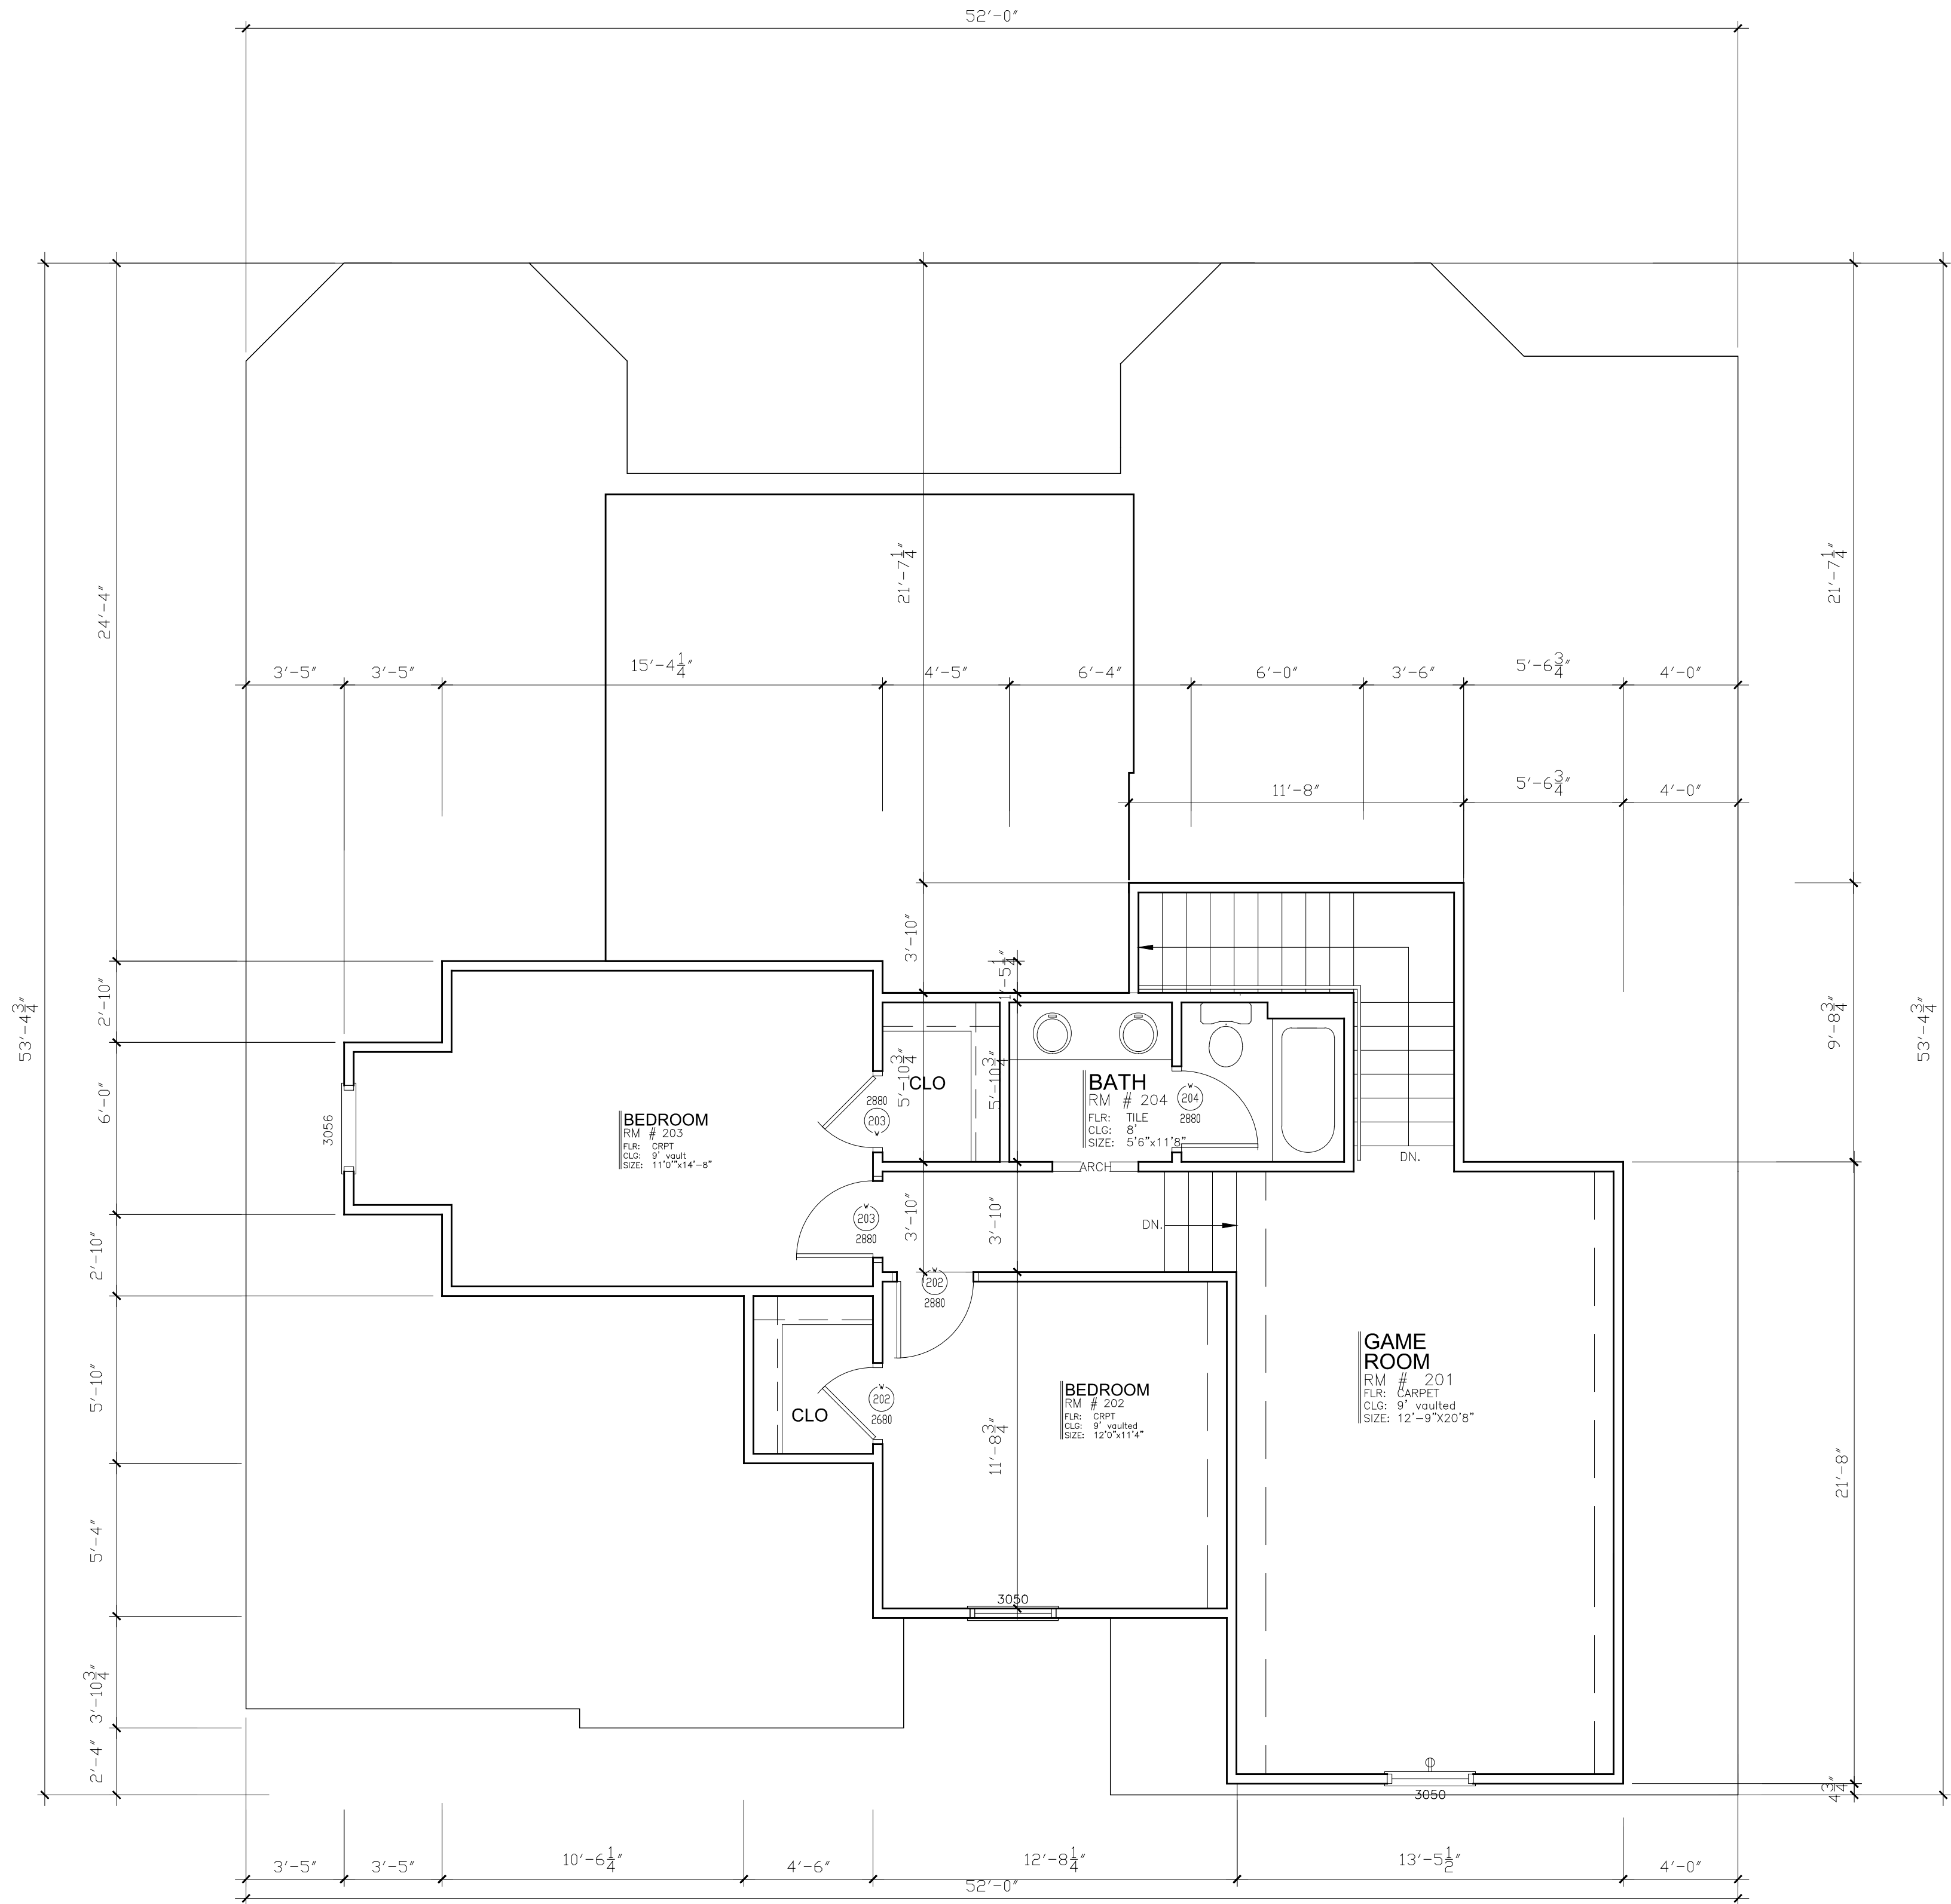

DESIGNED BY:		
DRAWN BY:		
DATE PLOTTED:		
ISSUE FOR PRICING / BIDDING:		
ISSUE FOR PERMIT APPLICATION:		
ISSUE FOR CONSTRUCTION:		
REVISIONS:		
#	DATE	COMMENTS

3206 FALL CREEK HIGHWAY • GRANBURY, TX 76049
THESE ARCHITECTURAL DRAWINGS HAVE BEEN PREPARED FOR ARCHITECTURAL DESIGN ONLY. CIVIL, STRUCTURAL, MECHANICAL, AND OTHER RELATED ENGINEERING DESIGN AND SPECIFICATIONS, AND ALL NECESSARY PERMITS, SHALL BE THE RESPONSIBILITY OF THE GENERAL CONTRACTOR. ALL MEASUREMENTS SHALL BE VERIFIED BY THE CONTRACTORS DOING THE RESPECTIVE WORK.

J ALLEN HOMES



COPYRIGHT 2019
THESE DRAWINGS, AS INSTRUMENTS OF SERVICE, ARE THE PROPERTY OF J ALLEN HOMES, INC. AND ARE NOT TO BE USED IN WHOLE OR PART, IN ANY MANNER, WITHOUT THE WRITTEN AUTHORIZATION OF J ALLEN HOMES, INC. UNAUTHORIZED USE OF THESE DRAWINGS WILL BE PROSECUTED TO THE FULL EXTENT OF THE LAW. READY BEING BOUGHT BY THE DESIGNATOR.

CATHERINE PLAN – 2 STORY
GRANBURY, TX

SHEET CONTENTS:
2ND FLOOR PLAN
SHEET NO.

A3

August 29, 2019

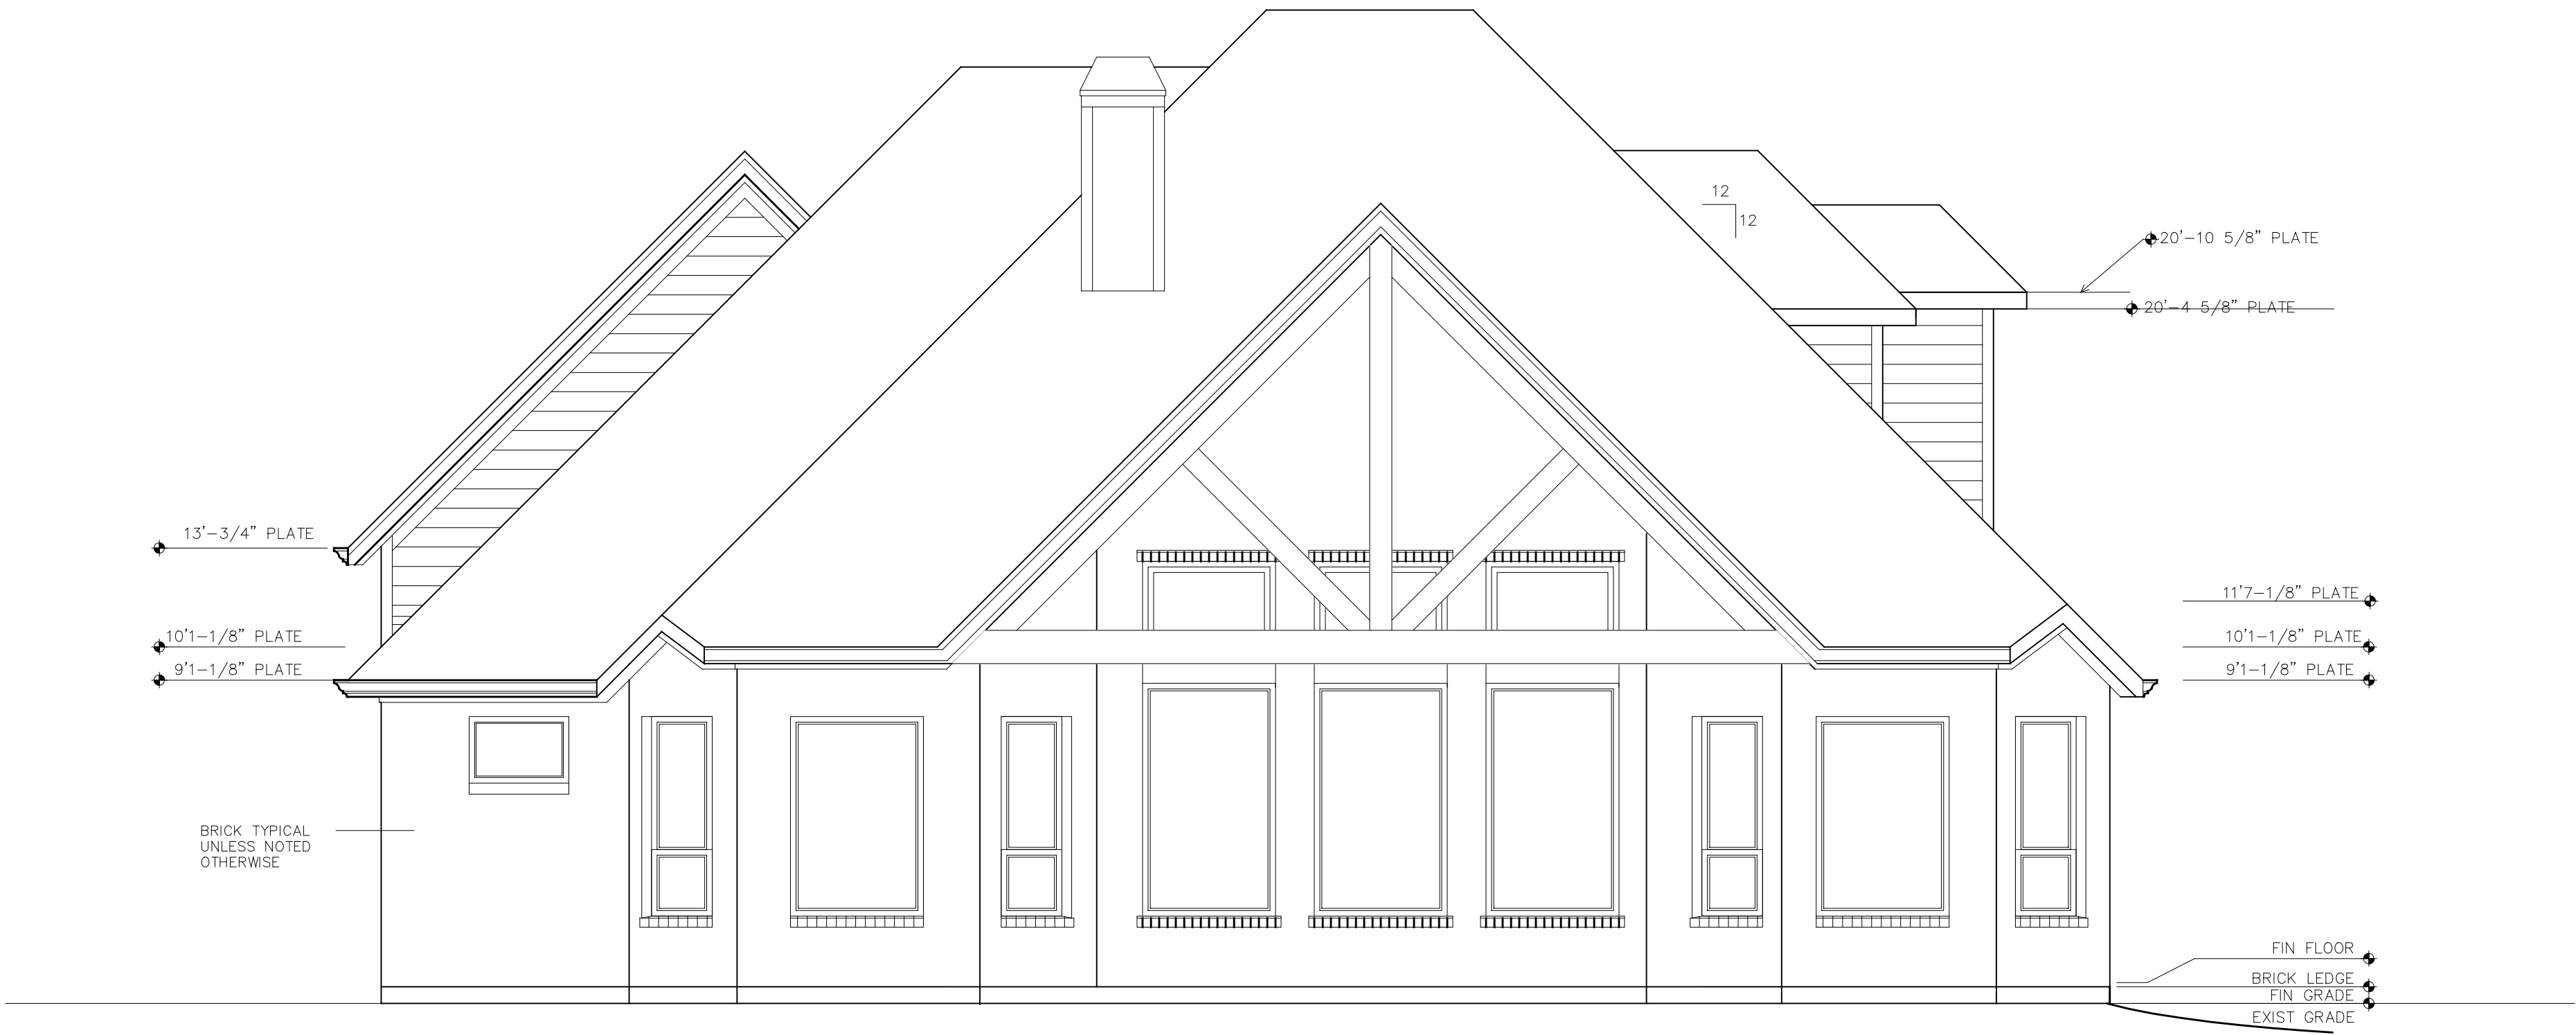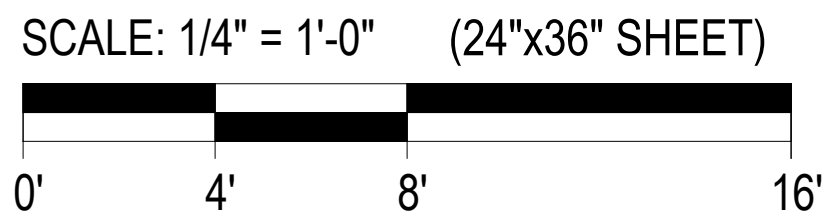

REAR ELEVATION
1/4"=1'-0"

DESIGNED BY:		
DRAWN BY:		
DATE PLOTTED:		
ISSUE FOR PRICING / BIDDING:		
ISSUE FOR PERMIT APPLICATION:		
ISSUE FOR CONSTRUCTION:		
REVISIONS:		
#	DATE	COMMENTS


3206 FALL CREEK HIGHWAY • GRANBURY, TX 76049
PH: 817-326-2547 FAX: 817-326-2548
THESE DRAWINGS ARE PREPARED FOR THE ARCHITECTURAL DESIGN ONLY. CIVIL, STRUCTURAL, MECHANICAL, AND OTHER RELATED ENGINEERING DESIGN AND SPECIFICATIONS ARE THE RESPONSIBILITY OF THE RESPECTIVE ENGINEERS. THE CONTRACTOR SHALL BE RESPONSIBLE FOR VERIFYING THE ACCURACY OF THE GENERAL CONTRACTOR. ALL MEASUREMENTS SHALL BE VERIFIED BY THE CONTRACTORS DOING THE RESPECTIVE WORK.

J ALLEN HOMES

COPYRIGHT 2019
THESE DRAWINGS, AS INSTRUMENTS OF SERVICE, ARE THE PROPERTY OF J ALLEN HOMES. NO PART OF THESE DRAWINGS MAY BE REPRODUCED OR TRANSMITTED IN ANY FORM OR BY ANY MEANS, ELECTRONIC OR MECHANICAL, WITHOUT THE WRITTEN PERMISSION OF J ALLEN HOMES. ANY UNAUTHORIZED USE OF THESE DRAWINGS SHALL BE AT THE USER'S SOLE RISK AND WITHOUT REMEDY BEING GRANTED BY THE ENGINEER.

CATHERINE PLAN – 2 STORY
GRANBURY, TX

SHEET CONTENTS:
REAR Elevation
SHEET NO.
A8
August 29, 2019


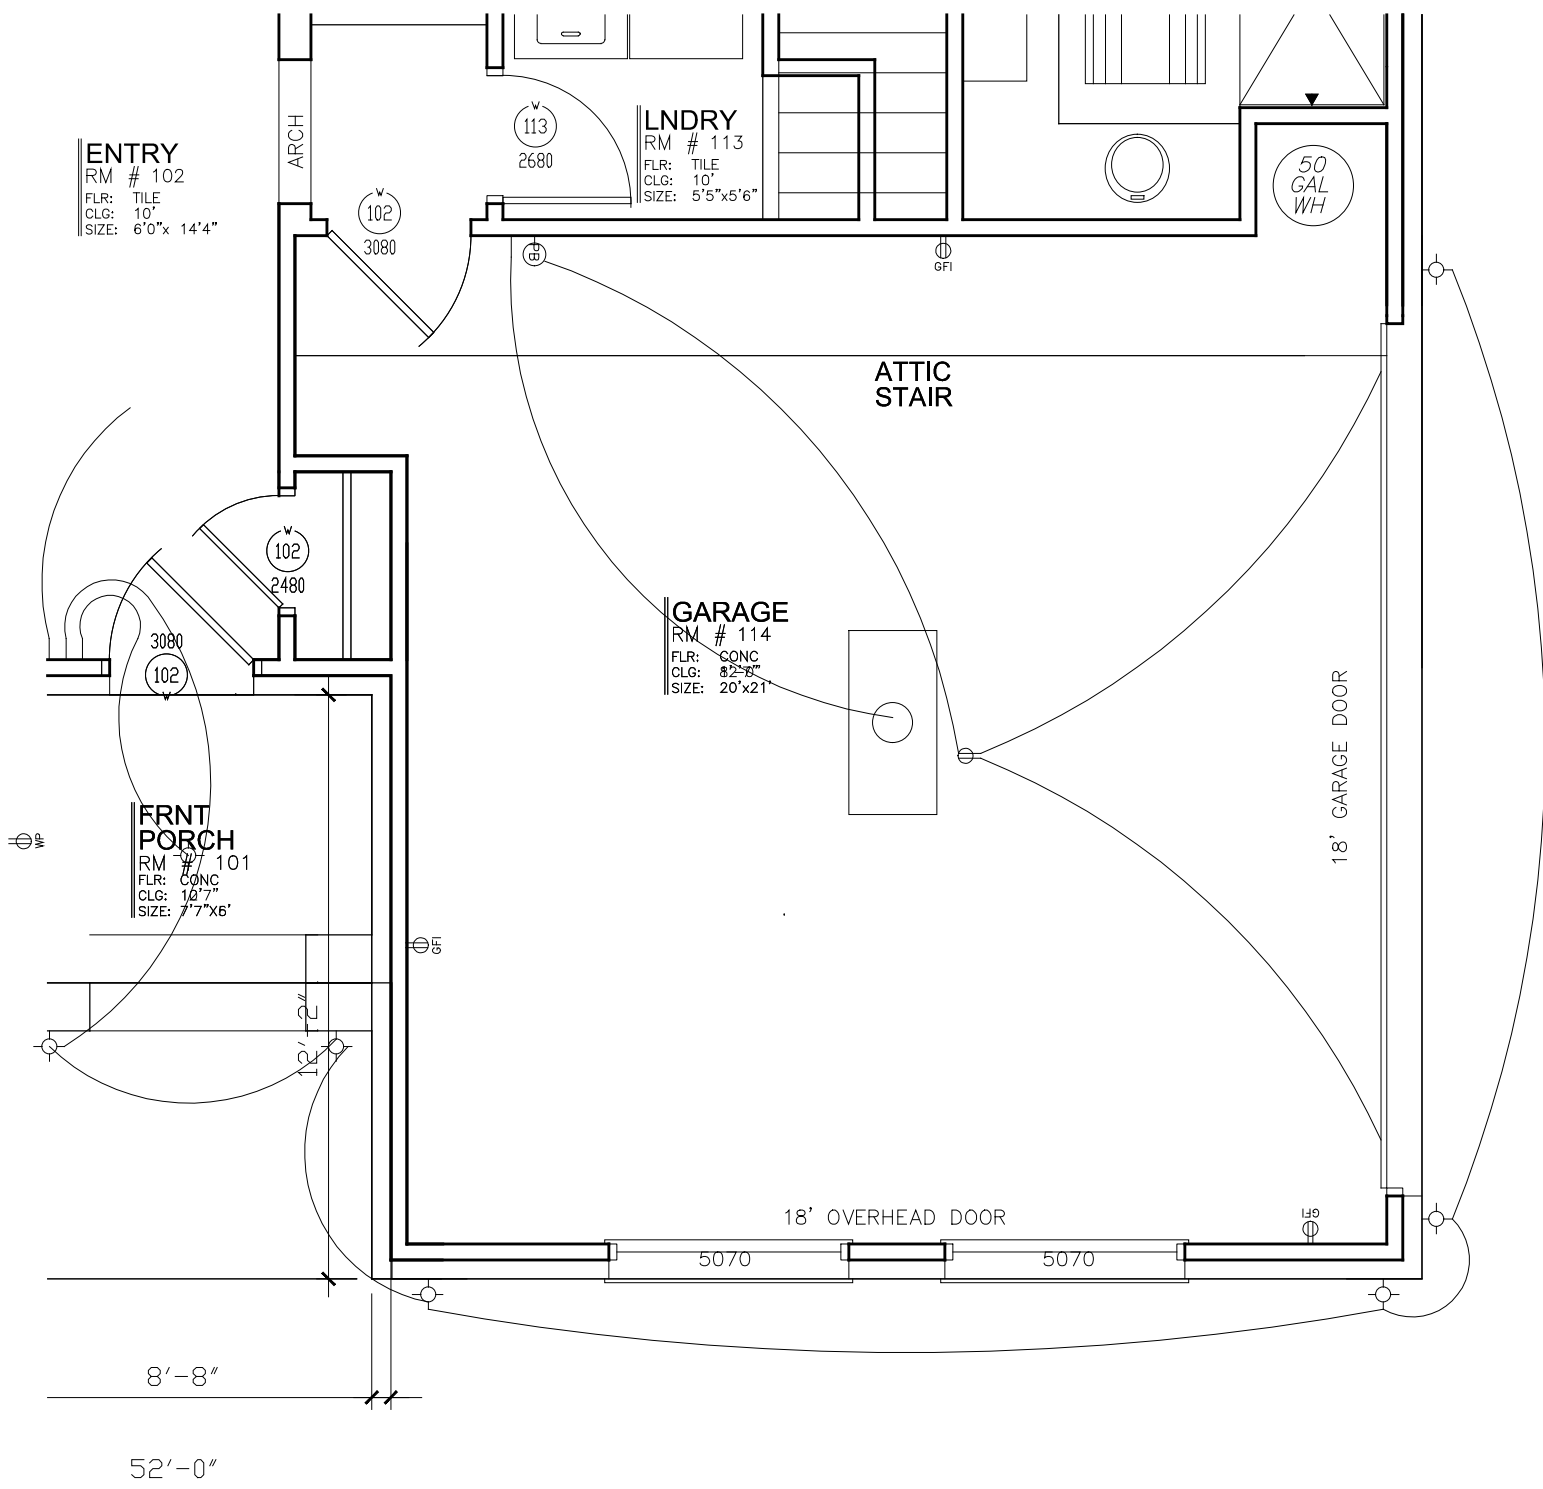


FIRST FLOOR ELECTRICAL PLAN
(SIDE GARAGE)
1/4"=1'-0"

TYPICAL ELECTRICAL/MECHANICAL NOTES

- 110V ELEC & COMM RECEPTACLES ARE TO BE INSTALLED @ + 18" AFF EXCEPT WHEN OVER COUNTER TOPS - UNO
- 110V ELEC & COMM RECEPTACLES OVER +36" COUNTER TOPS ARE TO BE INSTALLED @ + 44" AFF - UNO
- 110V ELEC & COMM RECEPTACLES OVER +32" AFF COUNTER TOPS ARE TO BE INSTALLED @ +40" AFF - UNO
- ALL 110V ELEC RECEPTACLES INSTALLED IN THE KITCHEN, UTILITY, BATHS, GARAGE, OR ANY INTERIOR ROOM WITH A WATER SOURCE ARE TO BE GROUND FAULT INTERRUPT DEVICES OR INSTALLED ON A GROUND FAULT INTERRUPT CIRCUIT
- ALL EXTERIOR ELEC RECEPTACLES ARE TO BE WATER PROOF
- ALL SWITCHES TO BE INSTALLED @ +44" AFF - UNO
- VERIFY ALL HVAC EQUIP POWER & GAS REQ'D & LOCATIONS w/ HVAC SUB-CONTR & BLDR PRIOR TO INSTALLATION
- FIELD VERIFY LOCATION OF ALL WALL WASHERS
- HOLD ALL SWITCHES AS CLOSE TO CORNER AS POSSIBLE

SCALE: 1/4" = 1'-0" (24"x36" SHEET)

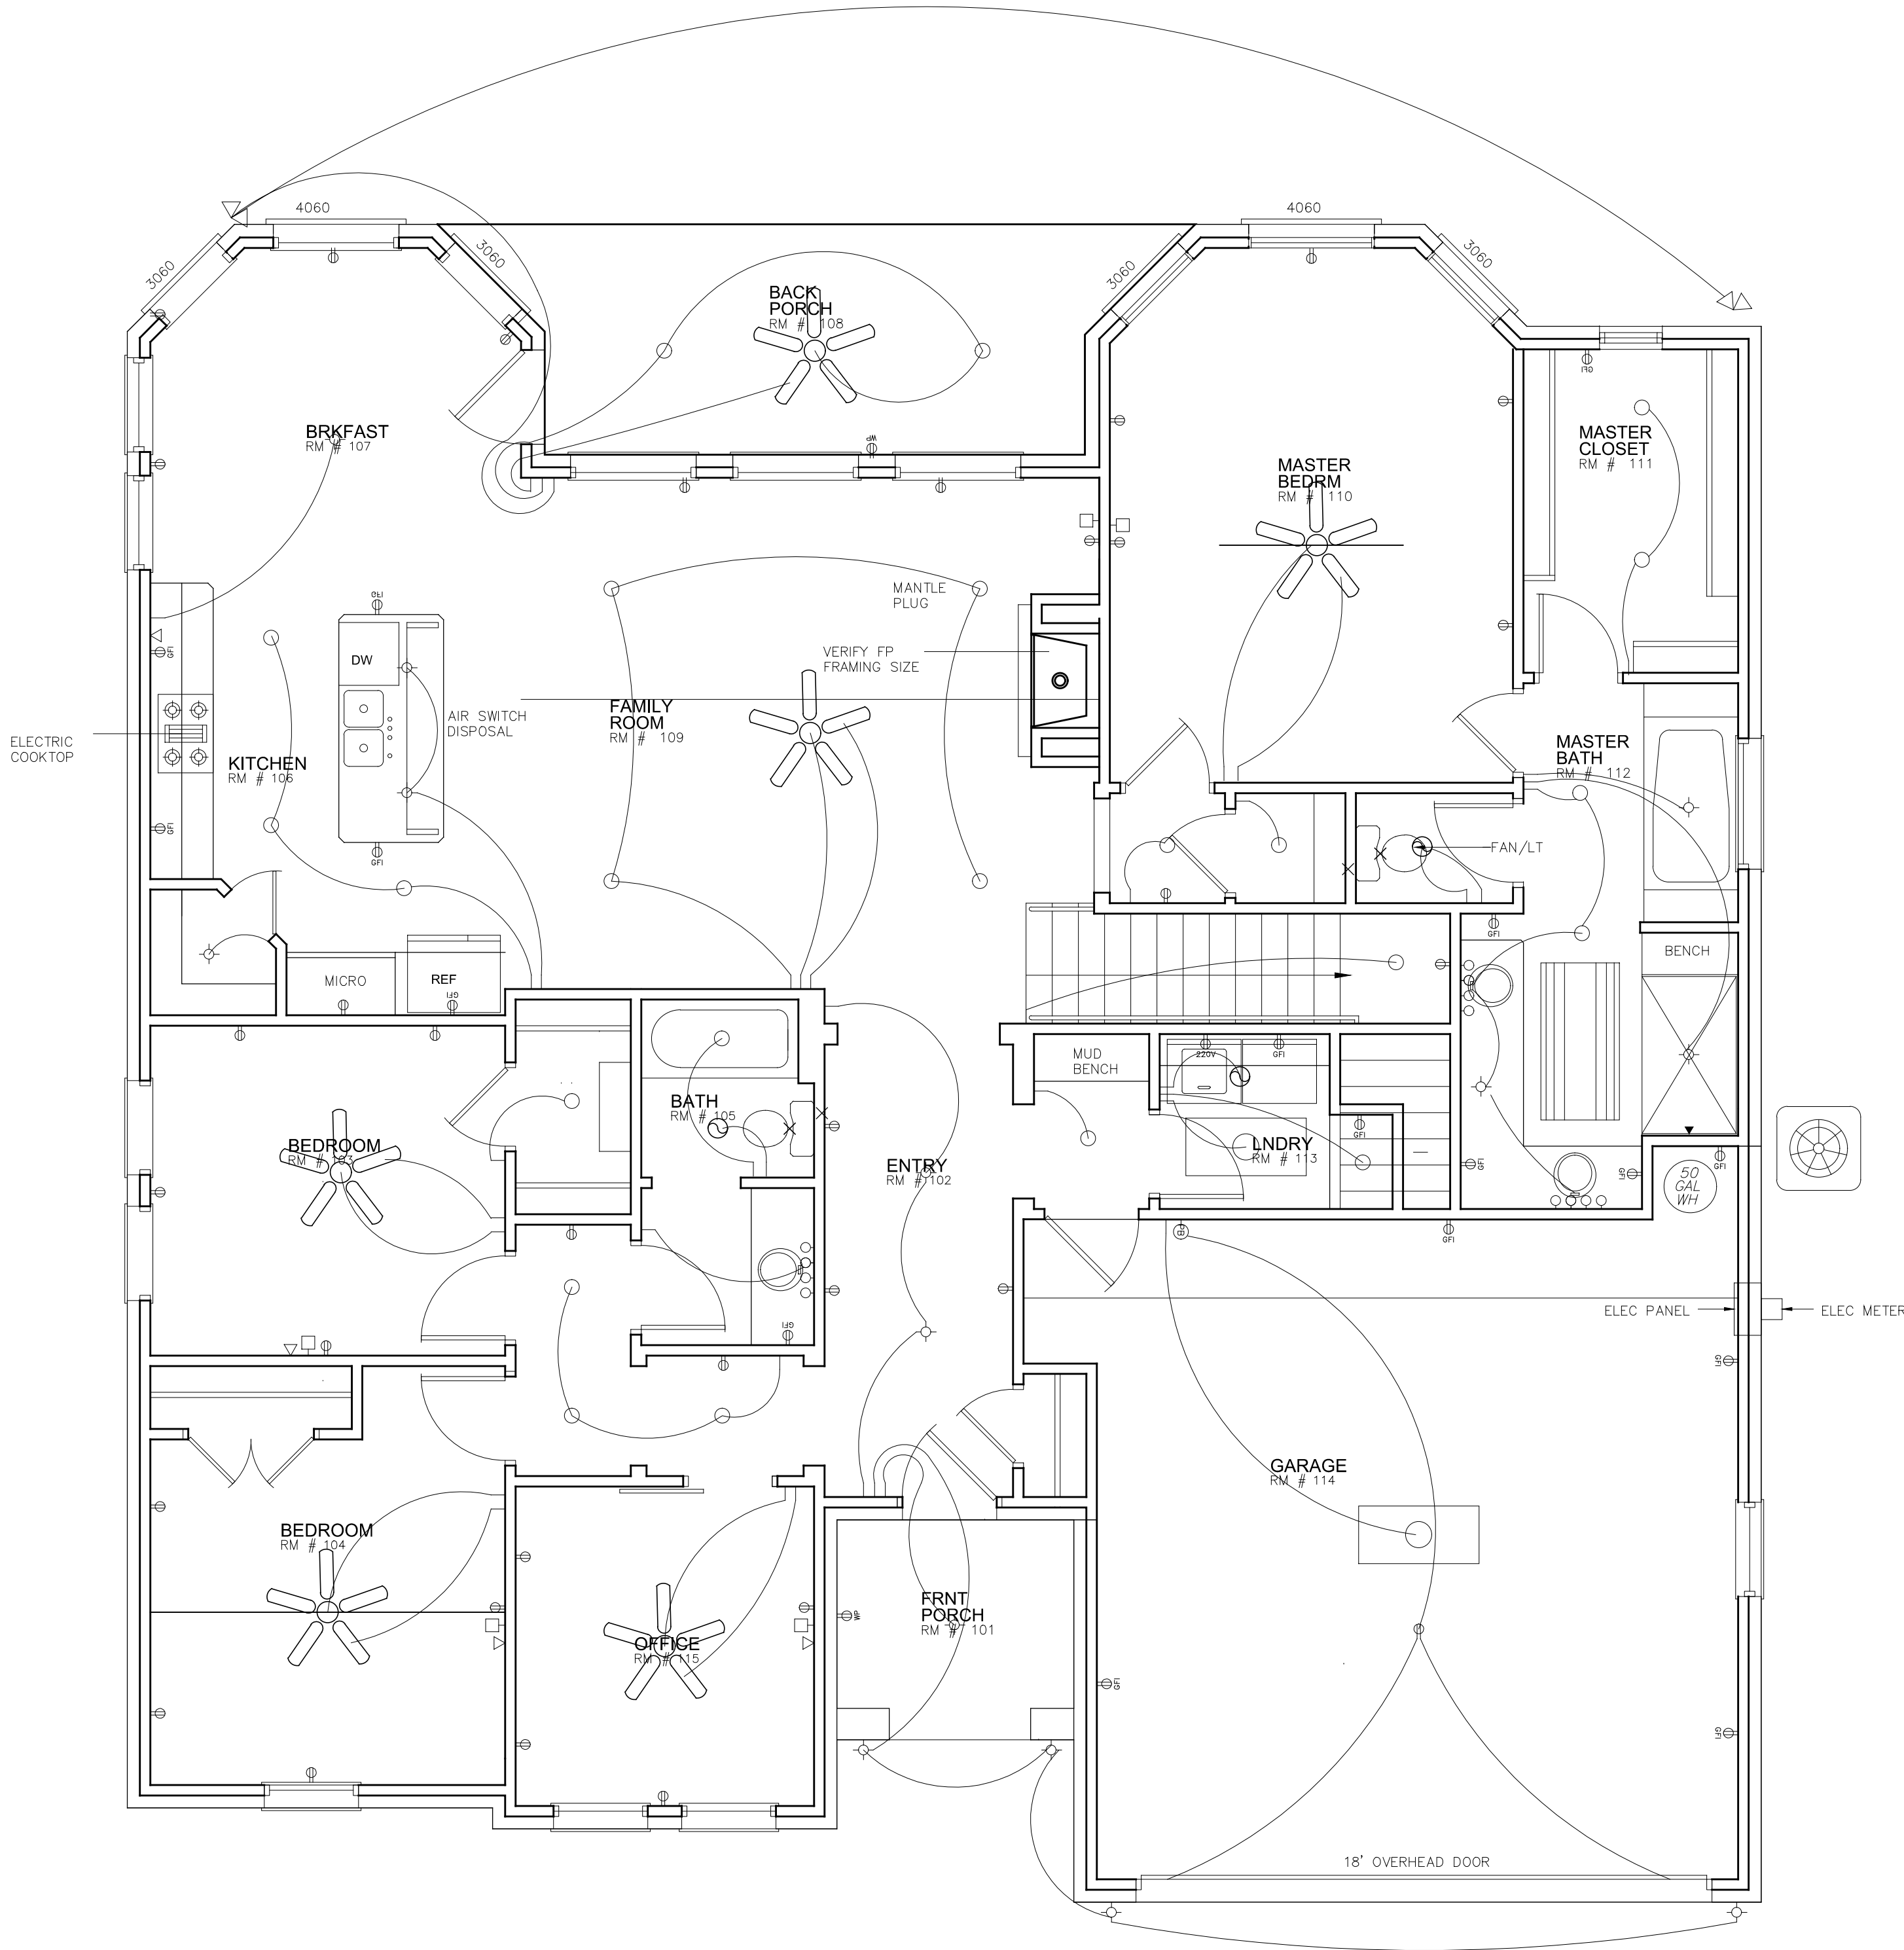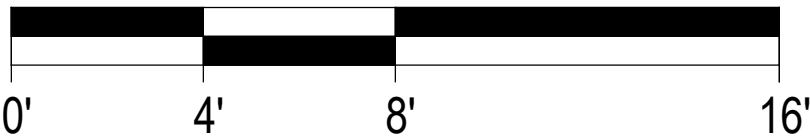

FIRST FLOOR ELECTRICAL PLAN
1/4"=1'-0"



DESIGNED BY:	_____	
DRAWN BY:	_____	
DATE PLOTTED:	_____	
ISSUE FOR PRICING / BIDDING: _____		
ISSUE FOR PERMIT APPLICATION: _____		
ISSUE FOR CONSTRUCTION _____		
REVISIONS:		
#	DATE	COMMENTS

3206 FALL CREEK HIGHWAY • GRANBURY, TX 76049
PH: 817-326-2547 FAX: 817-326-2548
THESE ARCHITECTURAL DRAWINGS HAVE BEEN PREPARED FOR J ALLEN HOMES, INC. BY J ALLEN HOMES, INC. AND ARE THE PROPERTY OF J ALLEN HOMES, INC. NO PART OF THESE DRAWINGS SHALL BE REPRODUCED OR TRANSMITTED IN ANY FORM OR BY ANY MEANS, ELECTRONIC OR MECHANICAL, WITHOUT THE WRITTEN PERMISSION OF J ALLEN HOMES, INC. THE USER SHALL BE RESPONSIBLE FOR OBTAINING ALL NECESSARY PERMITS AND FOR VERIFYING THE ACCURACY OF ALL MEASUREMENTS AND CONDITIONS OF THE GENERAL CONTRACTOR'S WORK. THE GENERAL CONTRACTOR SHALL BE RESPONSIBLE FOR VERIFYING THE CONTRACTOR'S WORKING CONDITIONS AND FOR VERIFYING THE CONTRACTOR'S WORKING CONDITIONS.

J ALLEN HOMES

COPYRIGHT 2019
J ALLEN HOMES, INC.
ALL RIGHTS RESERVED.
THESE DRAWINGS ARE THE EXCLUSIVE PROPERTY OF J ALLEN HOMES, INC. NO PART OF THESE DRAWINGS SHALL BE REPRODUCED OR TRANSMITTED IN ANY FORM OR BY ANY MEANS, ELECTRONIC OR MECHANICAL, WITHOUT THE WRITTEN PERMISSION OF J ALLEN HOMES, INC. THE USER SHALL BE RESPONSIBLE FOR OBTAINING ALL NECESSARY PERMITS AND FOR VERIFYING THE ACCURACY OF ALL MEASUREMENTS AND CONDITIONS OF THE GENERAL CONTRACTOR'S WORK. THE GENERAL CONTRACTOR SHALL BE RESPONSIBLE FOR VERIFYING THE CONTRACTOR'S WORKING CONDITIONS AND FOR VERIFYING THE CONTRACTOR'S WORKING CONDITIONS.

CATHERINE PLAN - 2 STORY
GRANBURY, TX

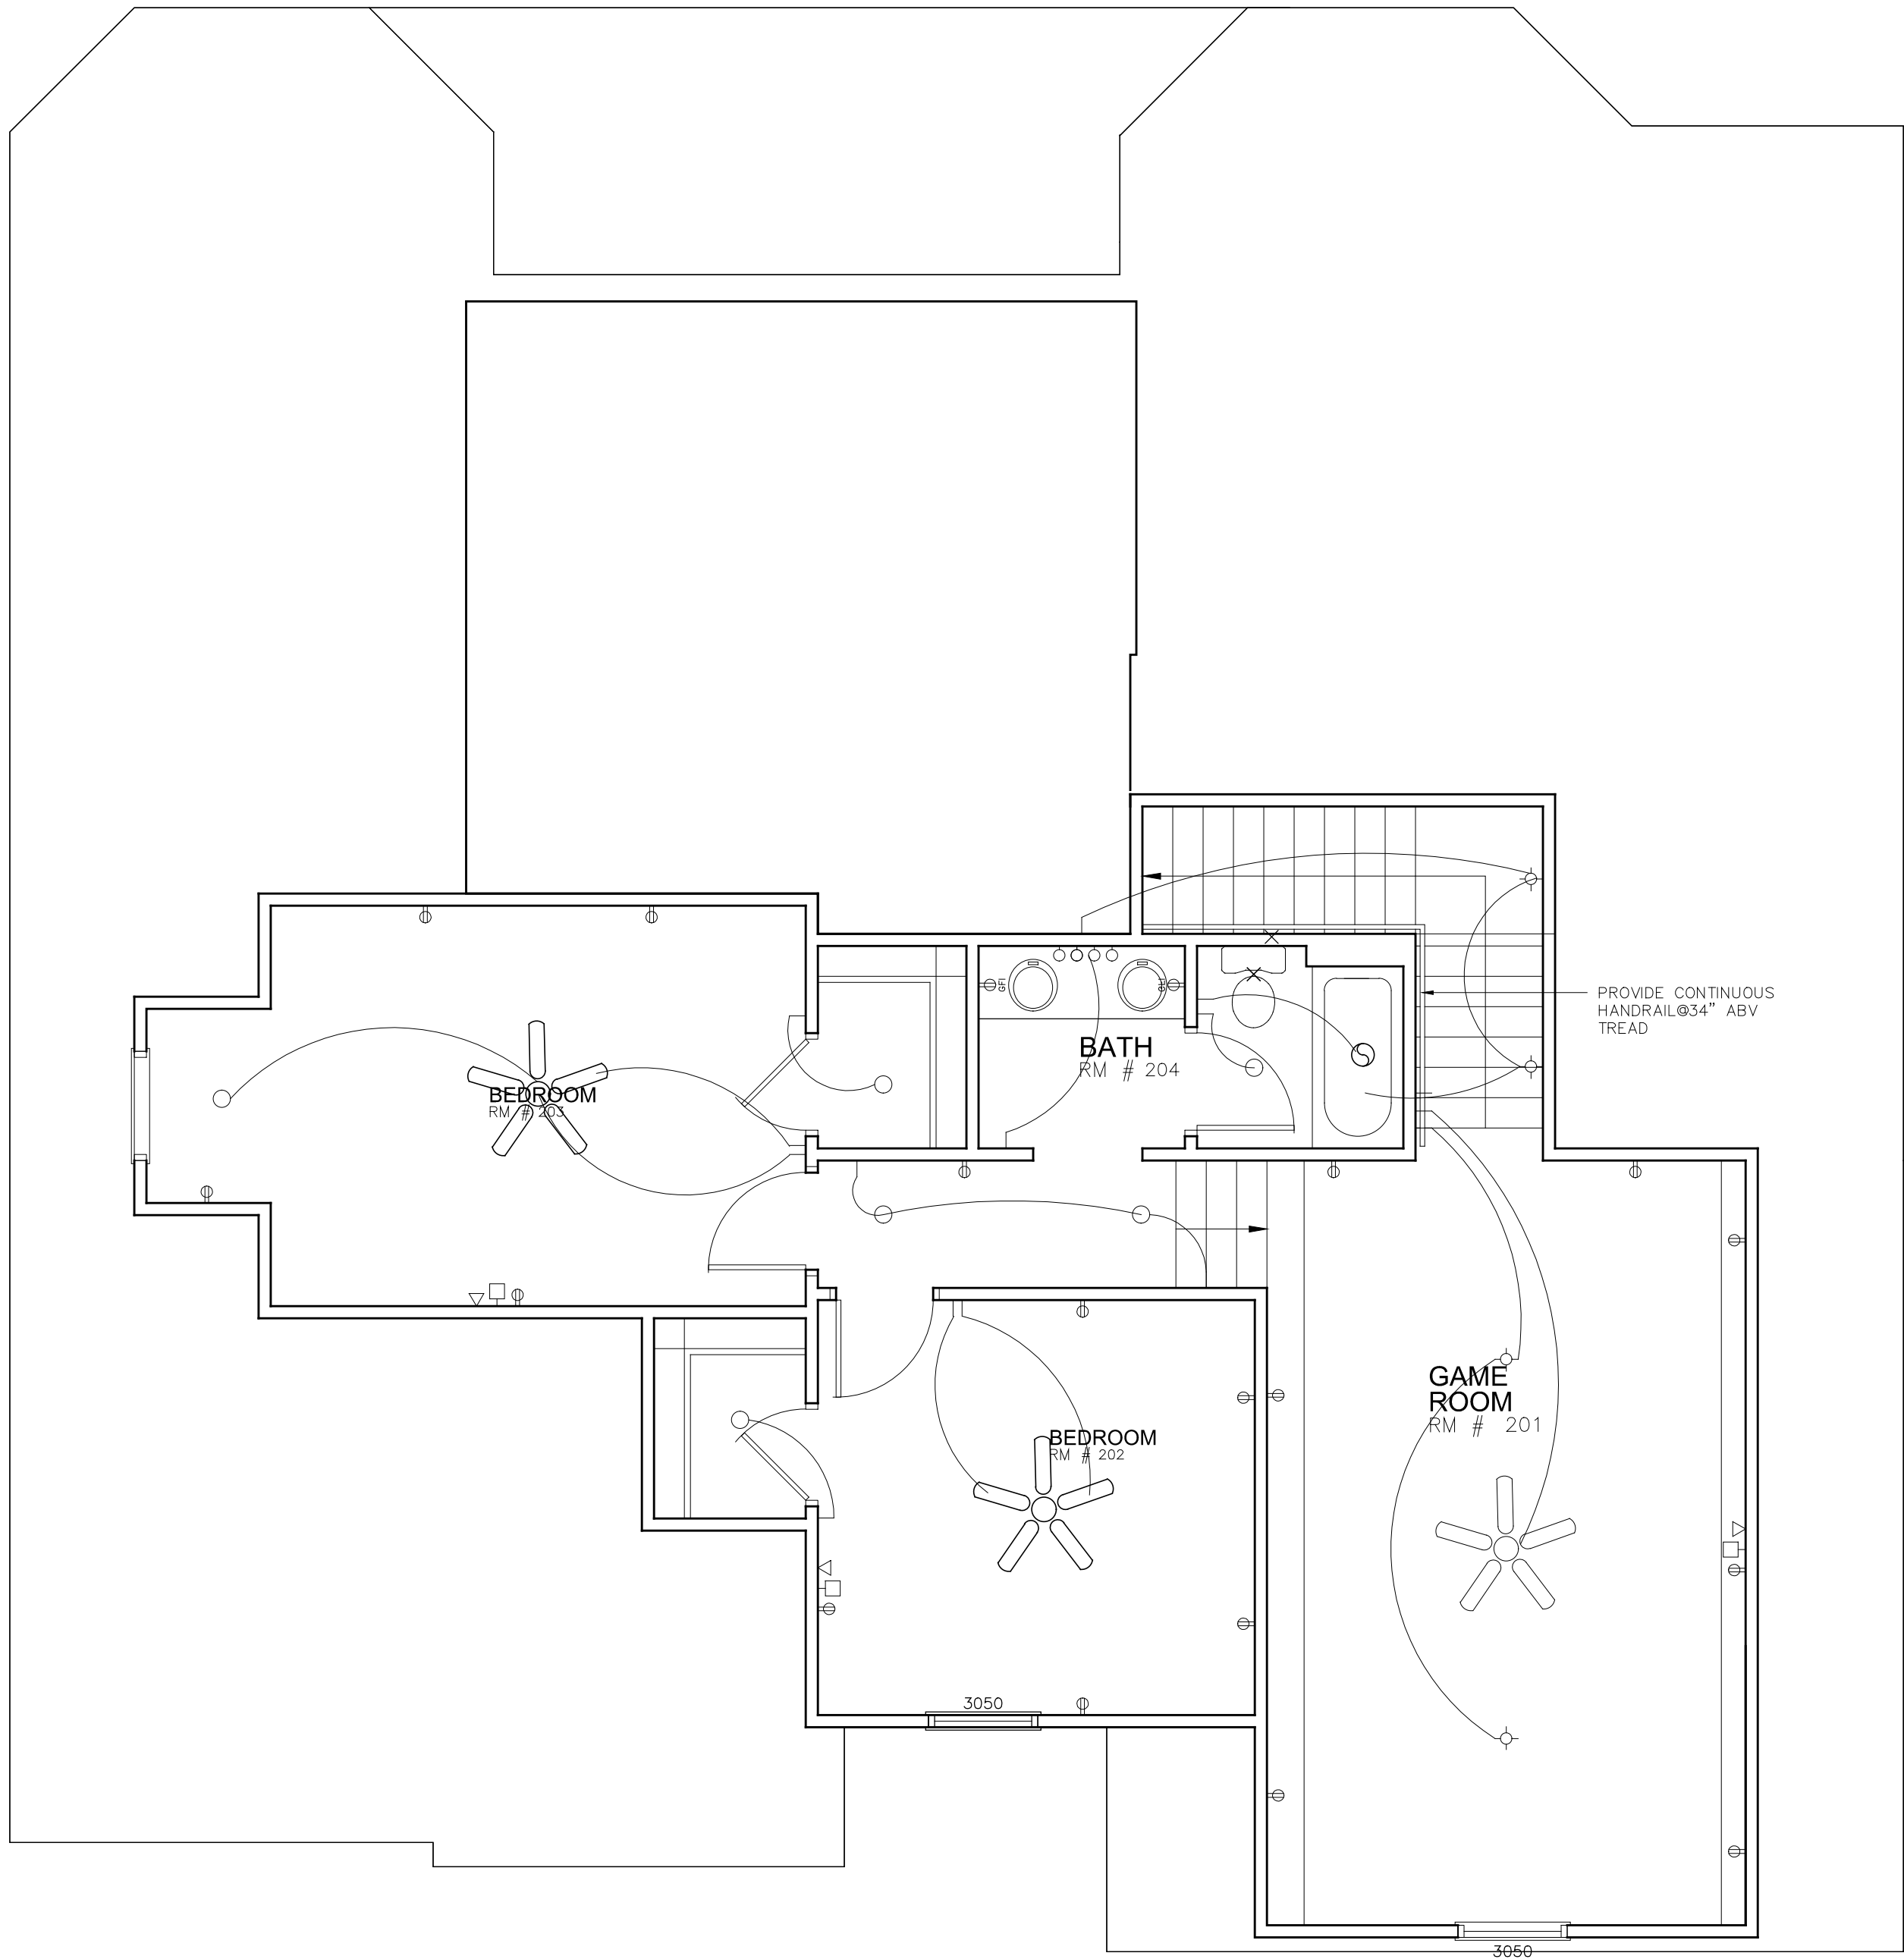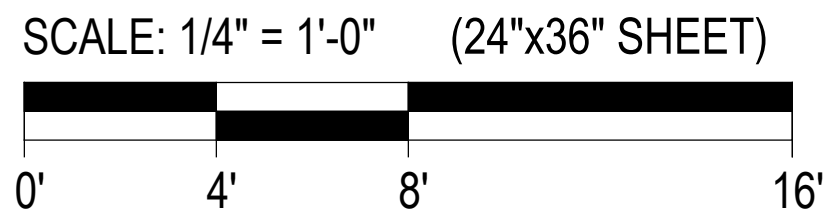

2nd FLOOR ELECTRICAL PLAN
1/4"=1'-0"

DESIGNED BY:
DRAWN BY:

DATE PLOTTED:		
ISSUE FOR PRICING / BIDDING:		
ISSUE FOR PERMIT APPLICATION:		
ISSUE FOR CONSTRUCTION:		
REVISIONS:		
#	DATE	COMMENTS

3206 FALL CREEK HIGHWAY • GRANBURY, TX 76049
PH: 817-326-2547 FAX: 817-326-2548
THESE ARCHITECTURAL DRAWINGS HAVE BEEN PREPARED FOR THE ARCHITECT BY J ALLEN HOMES, INC. FOR THE ARCHITECT'S USE ONLY. J ALLEN HOMES, INC. IS NOT RESPONSIBLE FOR THE ACCURACY OF THE INFORMATION PROVIDED BY THE ARCHITECT. THE ARCHITECT'S RESPONSIBILITY IS TO OBTAIN ALL NECESSARY PERMITS AND TO VERIFY THE INFORMATION PROVIDED BY THE ARCHITECT. THE ARCHITECT'S RESPONSIBILITY IS TO OBTAIN ALL NECESSARY PERMITS AND TO VERIFY THE INFORMATION PROVIDED BY THE ARCHITECT. THE ARCHITECT'S RESPONSIBILITY IS TO OBTAIN ALL NECESSARY PERMITS AND TO VERIFY THE INFORMATION PROVIDED BY THE ARCHITECT.

J ALLEN HOMES

COPYRIGHT 2019
ALL RIGHTS RESERVED
THESE ARCHITECTURAL DRAWINGS ARE THE EXCLUSIVE PROPERTY OF J ALLEN HOMES, INC. AND ARE NOT TO BE REPRODUCED, COPIED, OR TRANSMITTED IN ANY FORM OR BY ANY MEANS, WITHOUT THE WRITTEN PERMISSION OF J ALLEN HOMES, INC. THE USER OF THESE ARCHITECTURAL DRAWINGS SHALL BE RESPONSIBLE FOR OBTAINING ALL NECESSARY PERMITS AND FOR VERIFYING THE INFORMATION PROVIDED BY THE ARCHITECT.

CATHERINE PLAN – 2 STORY
GRANBURY, TX

SHEET CONTENTS:
2ND FLOOR ELECTRICAL PLAN
SHEET NO.
A13
August 29, 2019