

SHEET INDEX

#	DESCRIPTION
1	SITE PLAN
2	FOUNDATION PLAN
3	1ST FLOOR PLAN
4	ROOF PLAN
5	FRONT & REAR ELEVATIONS
6	SIDE ELEVATIONS
7	ELECTRICAL PLAN



CALEB - 1

DATE: 11.4.16

COPYRIGHT 2016 R.D.S.
THESE DRAWINGS, AS INSTRUMENTS OF SERVICE, ARE THE EXCLUSIVE PROPERTY OF THE DESIGNER. NO PART OF THESE DRAWINGS MAY BE REPRODUCED OR TRANSMITTED IN ANY FORM OR BY ANY MEANS, WITHOUT HIS EXPRESS WRITTEN PERMISSION. UNAUTHORIZED USE OF THESE DRAWINGS WILL BE CONSIDERED A VIOLATION OF THE PROFESSIONAL REMEDY BEING SOUGHT BY THE DESIGNER.

3206 FALL CREEK HIGHWAY • GRANBURY, TX 76049
THESE ARCHITECTURAL DRAWINGS HAVE BEEN PREPARED FOR ARCHITECTURAL DESIGN ONLY. CIVIL, STRUCTURAL, MECHANICAL, ELECTRICAL, AND PLUMBING DRAWINGS ARE THE RESPONSIBILITY OF THE RESPECTIVE ENGINEERS. COMPLIANCE TO THESE DRAWINGS WILL BE THE RESPONSIBILITY OF THE CONTRACTORS DOING THE RESPECTIVE WORK. VERIFIED BY THE CONTRACTORS DOING THE RESPECTIVE WORK.

J ALLEN HOMES


CALEB PLAN - 1 STORY

GRANBURY, TX

RESIDENTIAL
DESIGN STUDIO


FINAL
FOR CONSTRUCTION

5
ELEVATIONS

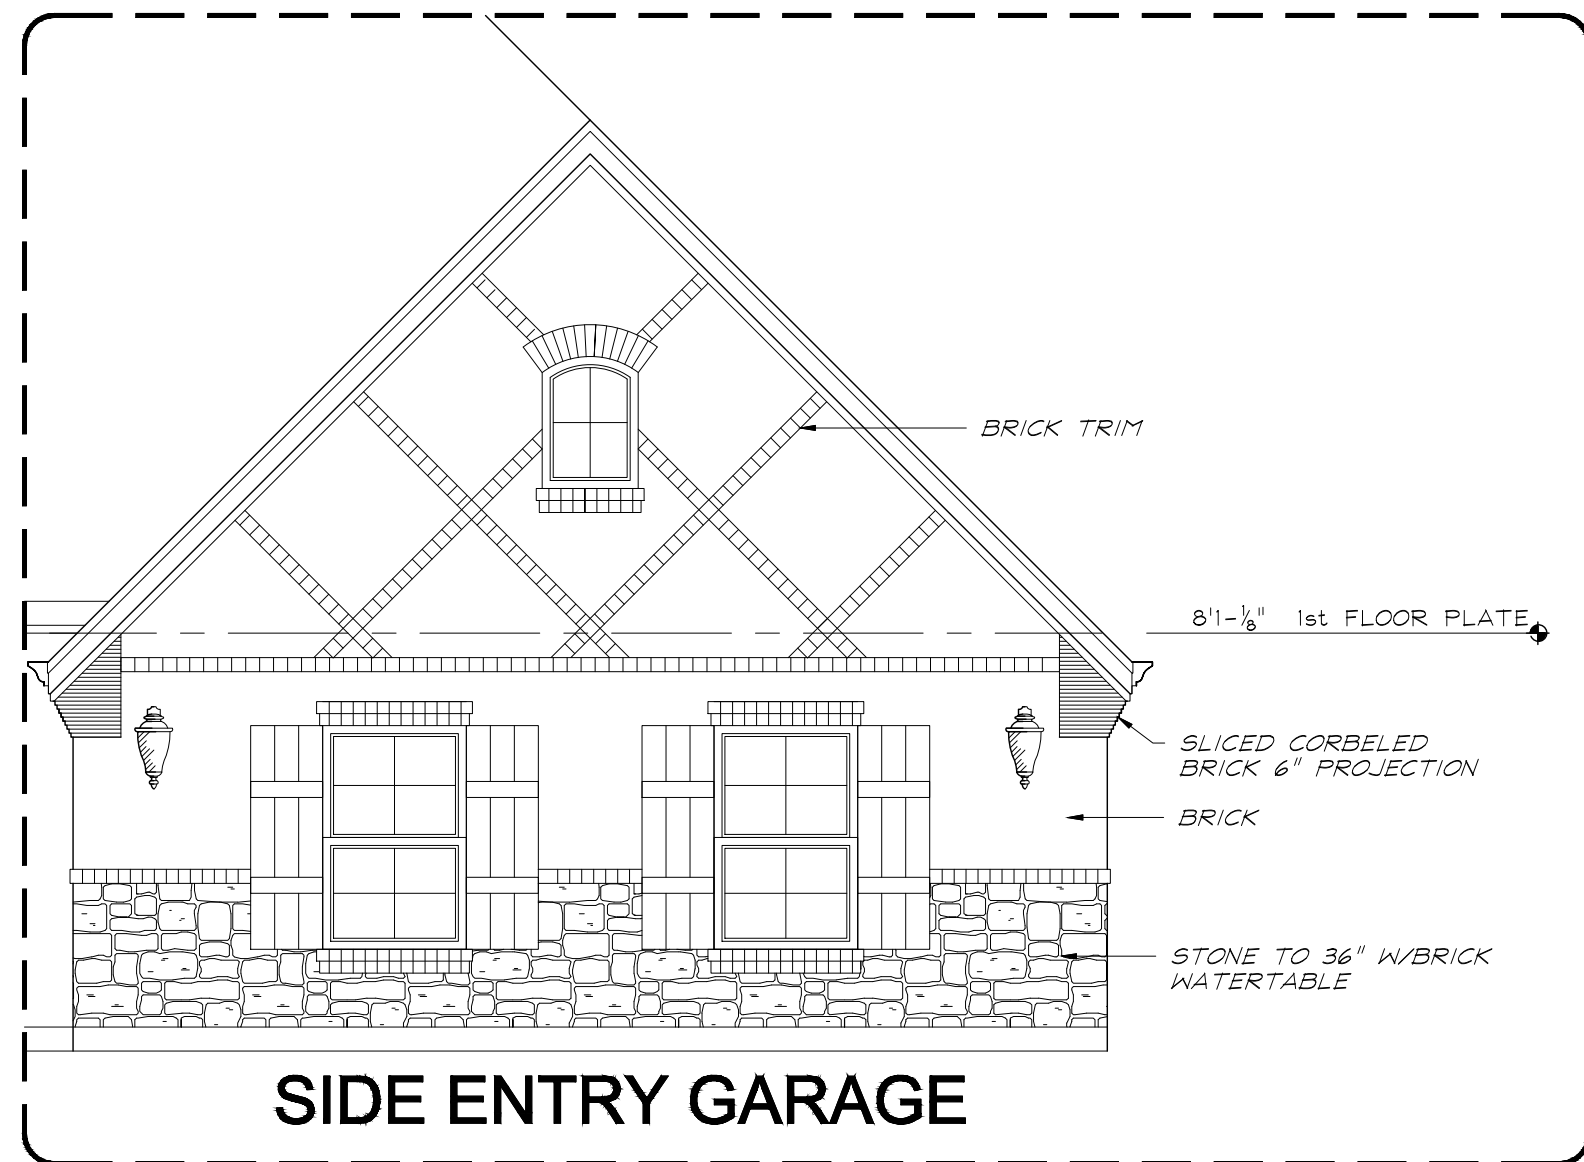

SIDE ENTRY GARAGE
PARTIAL FRONT ELEVATION

SCALE: 1/4" = 1'-0"

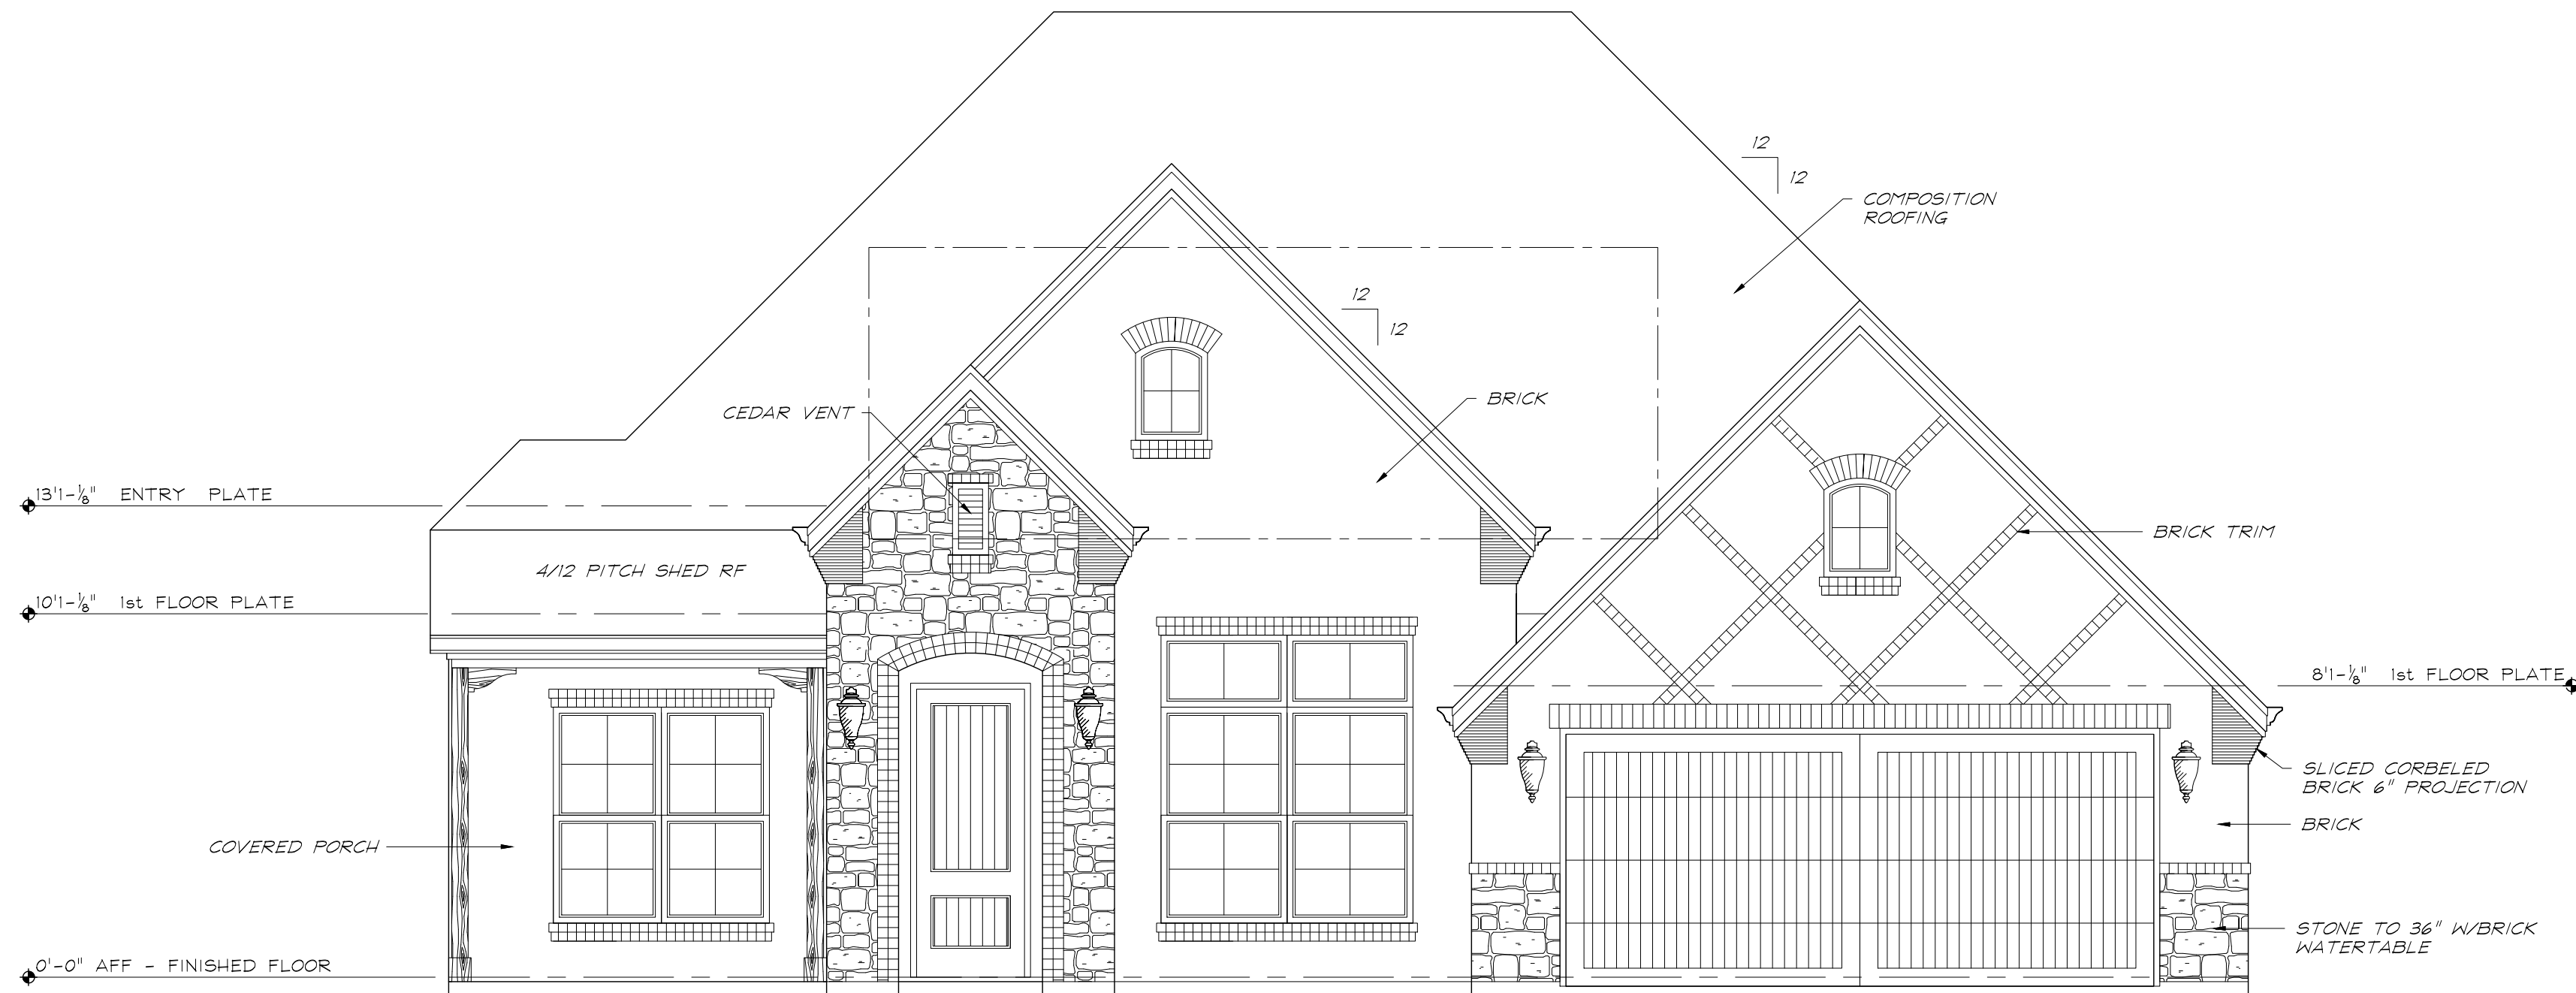


FRONT ELEVATION - B

SCALE: 1/4" = 1'-0"




REAR ELEVATION

SCALE: 1/4" = 1'-0"

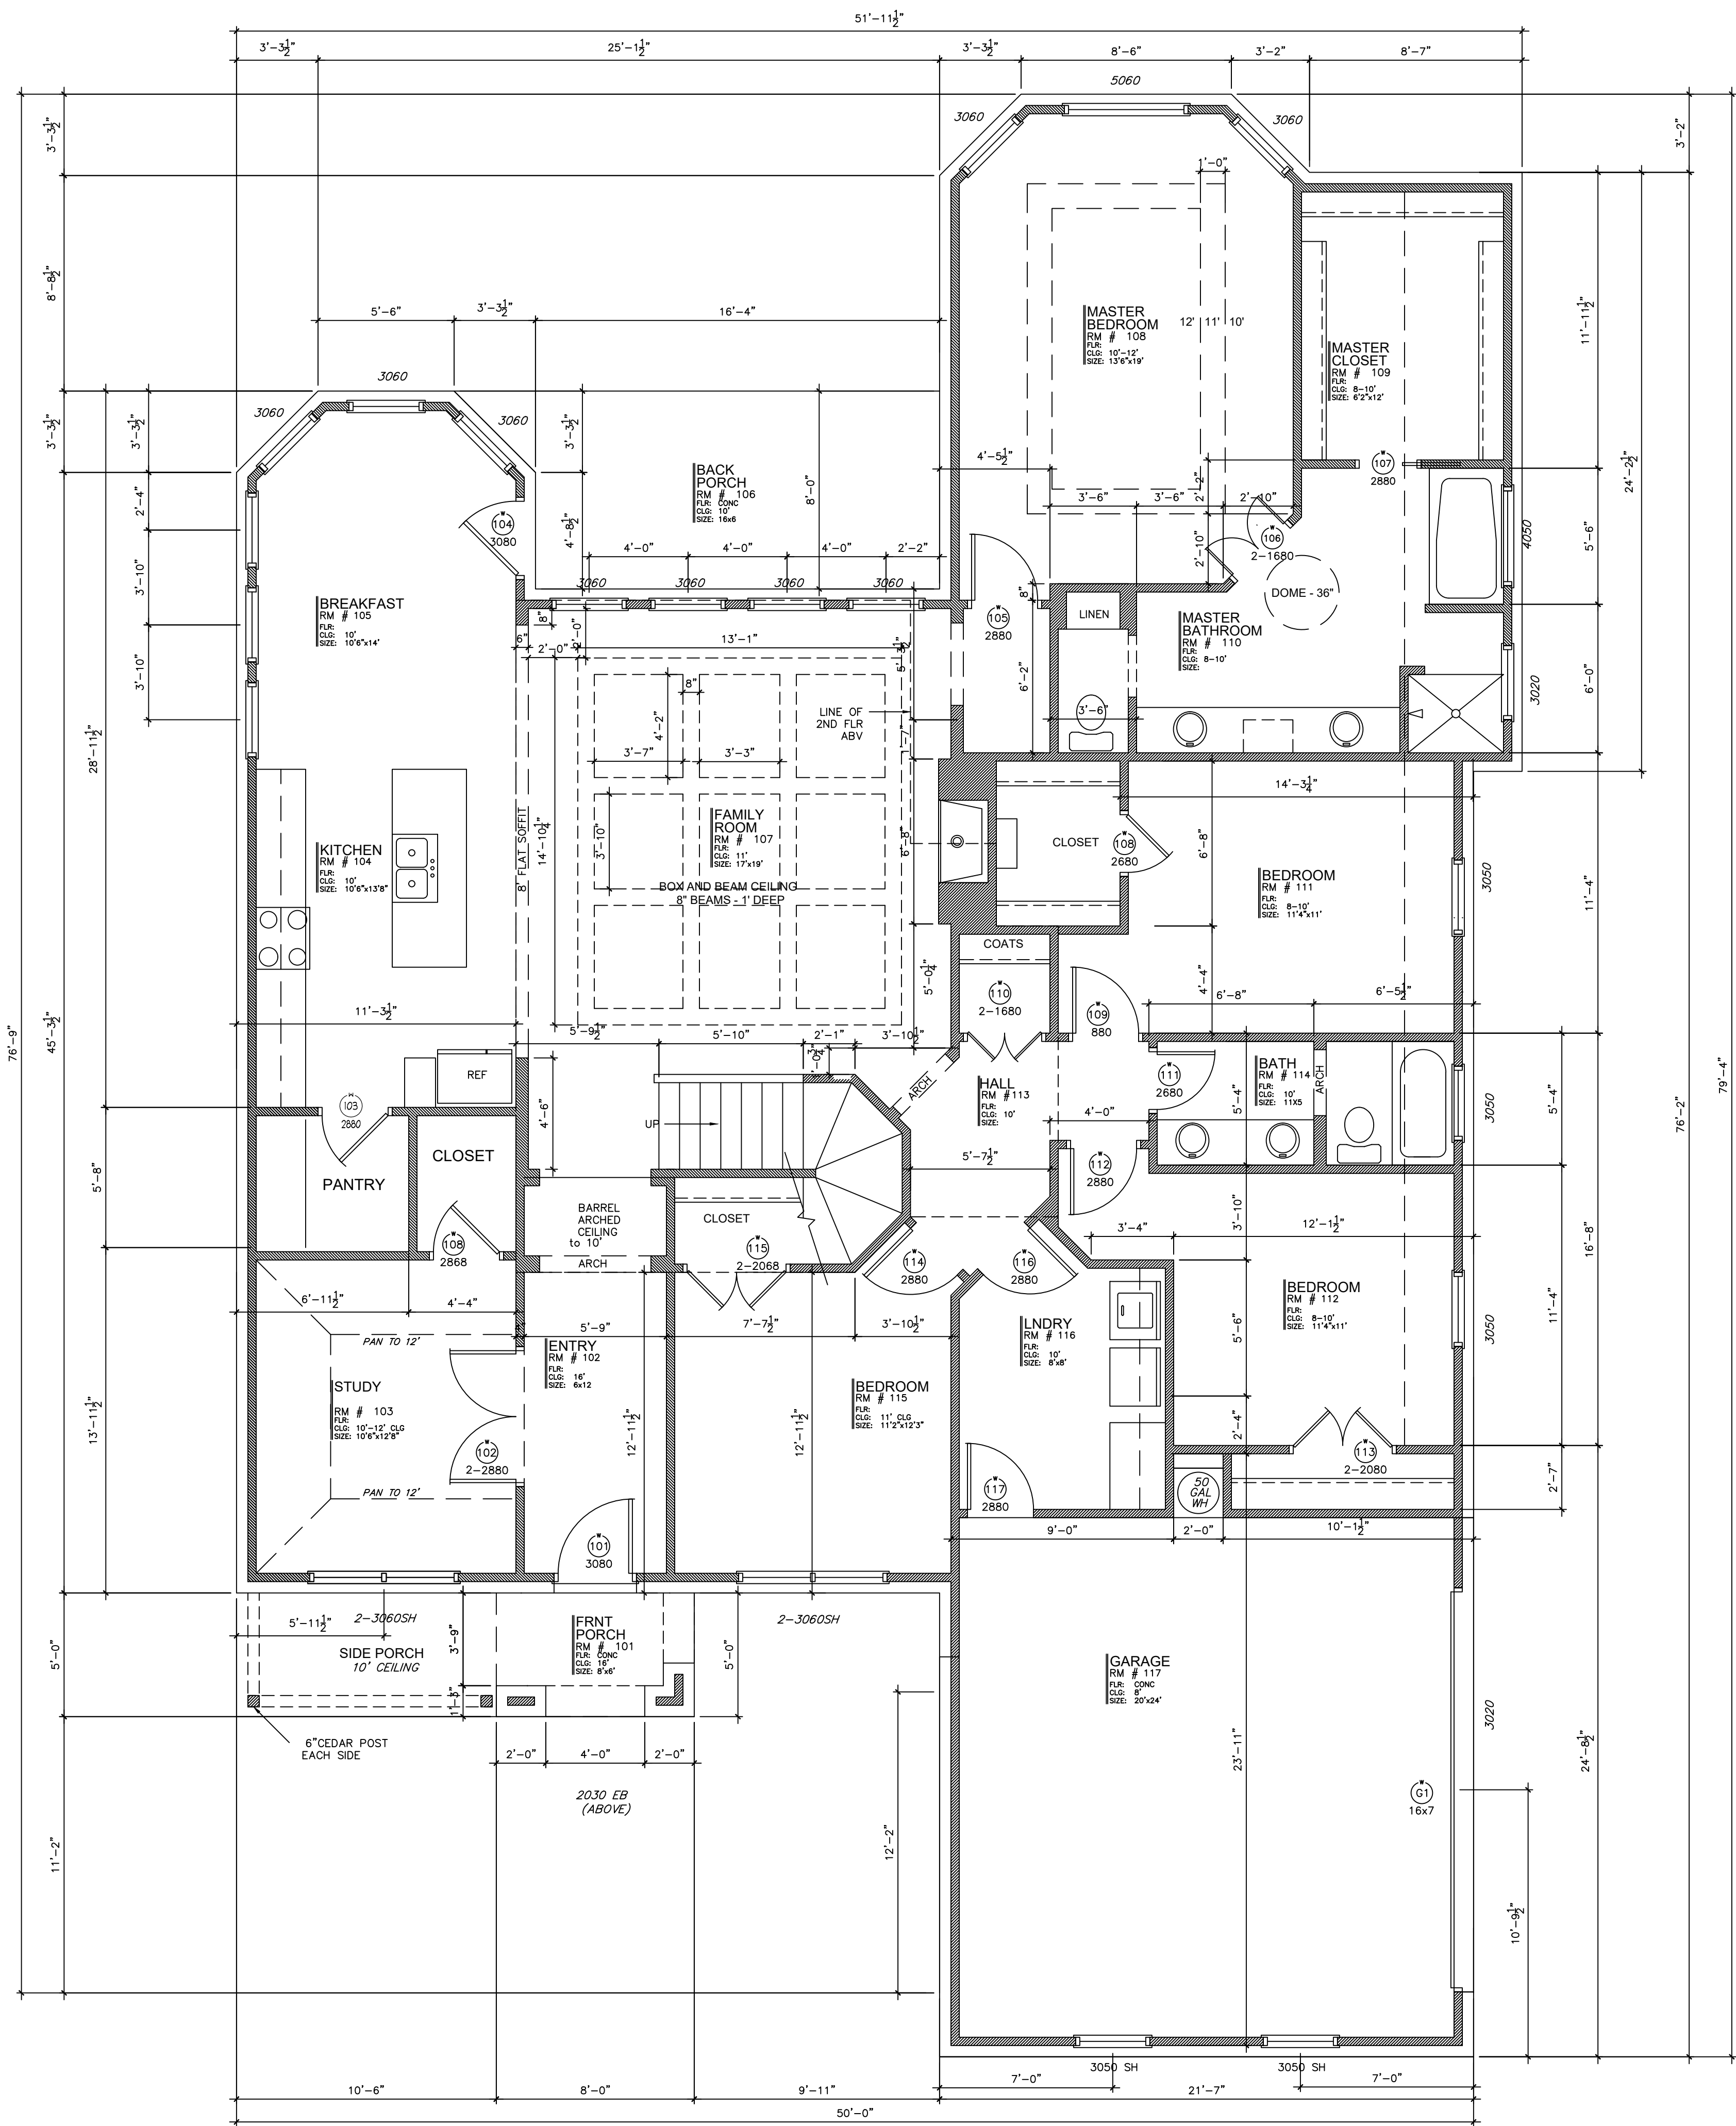

FIRST FLOOR PLAN
1/4"=1'-0"

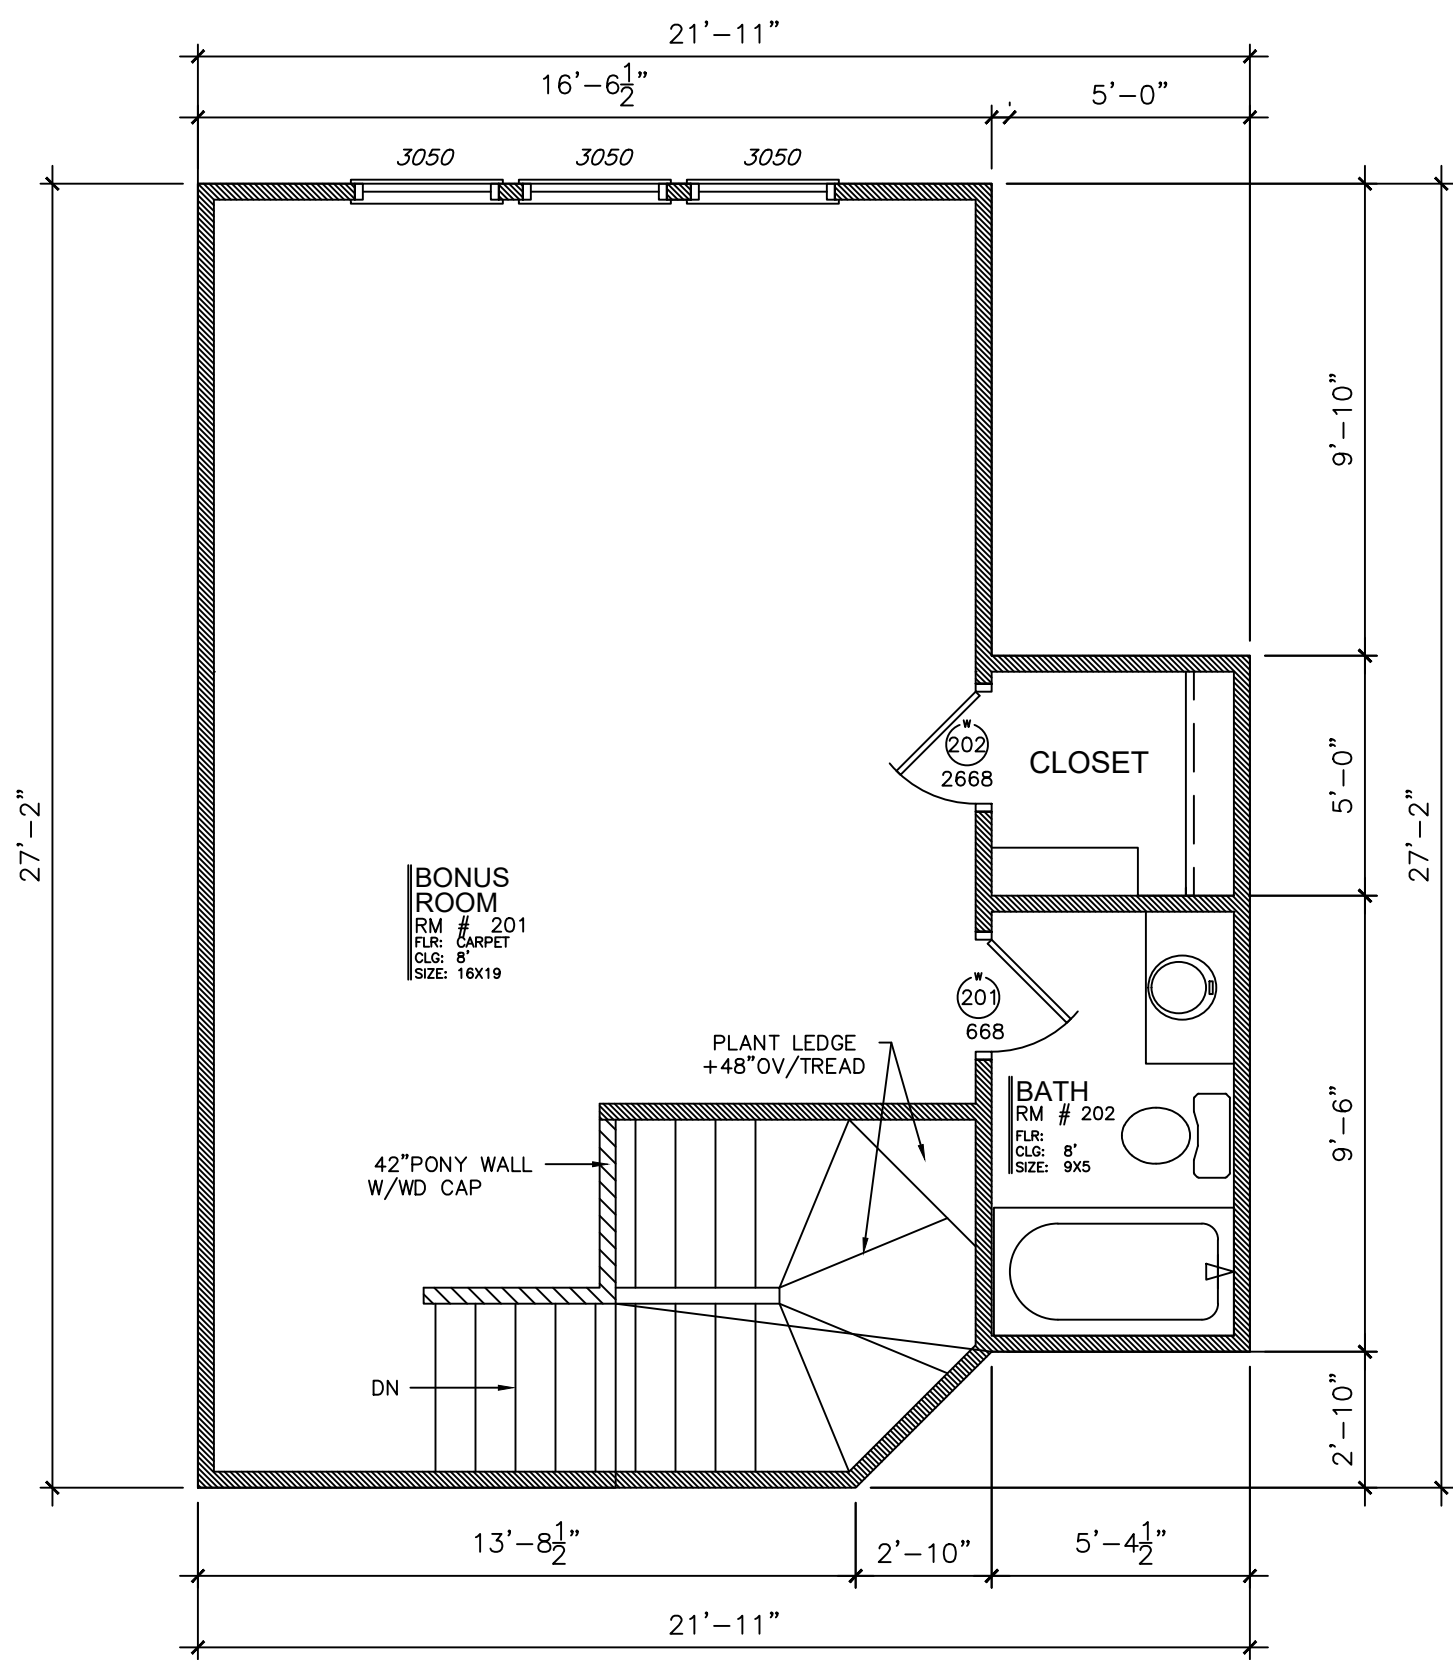

BONUS ROOM
1/4"=1'-0"

SHEET INDEX

#	DESCRIPTION
1	SITE PLAN
2	FOUNDATION PLAN
3	1ST FLOOR PLAN
4	ROOF PLAN
5	FRONT & REAR ELEVATIONS
6	SIDE ELEVATIONS
7	ELECTRICAL PLAN

LIVING SPACE-F1	2502
LIVING SPACE-F2	520
FRONT PORCH	32
BACK PORCH	136
GARAGE	470
TOTAL	3200



CALEB - 1

DATE: 11.4.16

COPYRIGHT 2016, P.D.S.
THESE DRAWINGS, AS INSTRUMENTS OF SERVICE,
ARE THE EXCLUSIVE PROPERTY OF THE DESIGNER,
AND ARE NOT TO BE USED IN WHOLE OR PART
FOR ANY OTHER PROJECT WITHOUT THE WRITTEN
CONSENT OF THE DESIGNER. THE DESIGNER
SUSPECTS THE USER TO LEGAL REMEDY BEING
SOUGHT BY THE DESIGNER.

3206 FALL CREEK HIGHWAY • GRANBURY, TX 76049
PH: 817-326-2247 FAX: 817-326-2248
THESE DRAWINGS ARE THE PROPERTY OF J ALLEN HOMES
ARCHITECTURAL DESIGN ONLY. CIVIL, STRUCTURAL, MECHANICAL,
AND OTHER RELATED ENGINEERING DESIGN AND SPECIFICATIONS
SHALL BE THE RESPONSIBILITY OF THE ENGINEER. THE ENGINEER
COMPLIANCE TO THESE DRAWINGS WILL BE THE RESPONSIBILITY
OF THE GENERAL CONTRACTOR. ALL MEASUREMENTS SHALL BE
VERIFIED BY THE CONTRACTOR DURING THE RESPECTIVE WORK.

J ALLEN HOMES
CALEB PLAN - 1 STORY
GRANBURY, TX

RESIDENTIAL
DESIGN STUDIO

FINAL
FOR CONSTRUCTION

3
FLOOR PLAN