

SHEET INDEX

#	DESCRIPTION
1	SITE PLAN
2	FOUNDATION PLAN
3	1ST FLOOR PLAN
4	ROOF PLAN
5	FRONT & REAR ELEVATIONS
6	SIDE ELEVATIONS
7	ELECTRICAL PLAN



PLAN # 5555

DATE: 2/4/11

COPYRIGHT 2011 R.D.S. ALL RIGHTS RESERVED. THESE DRAWINGS ARE THE EXCLUSIVE PROPERTY OF THE DESIGNER. NO PART OF THESE DRAWINGS MAY BE REPRODUCED OR TRANSMITTED IN ANY FORM OR BY ANY MEANS, WITHOUT THE EXPRESS WRITTEN PERMISSION OF THE DESIGNER. UNAUTHORIZED USE OF THESE DRAWINGS WILL BE PROSECUTED TO THE FULL EXTENT OF THE LAW. SOUGHT BY THE DESIGNER.

3206 FALL CREEK HIGHWAY • GRANBURY, TX 76049
TEL: 817-332-2547 • FAX: 817-332-2548
R.D.S. ARCHITECTURAL DESIGN, INC. IS A QUAL STRUCTURAL MECHANICAL AND ELECTRICAL DESIGN ONLY. THE RESPONSIBILITY OF THE CONTRACTOR TO VERIFY THE COMPLIANCE OF THESE DRAWINGS WITH THE RESPECTIVE LOCAL, STATE AND FEDERAL CODES AND THE RESPONSIBILITY OF THE CONTRACTOR TO VERIFY THE COMPLIANCE OF THESE DRAWINGS WITH THE RESPECTIVE LOCAL, STATE AND FEDERAL CODES.

PROJECT INFORMATION
OWNER: JAMES H. HARRIS
150 BECA ROAD CT
LOT 151 ISLAND II -B4
THE ISLAND II
GRANBURY, TX

RESIDENTIAL
DESIGN STUDIO


SQUARE FOOTAGE

1/18/13	5:12
FIRST FLOOR AC.	2969
SECOND FLOOR AC.	0
GARAGE	797
PORCHES	271
TOTAL	4027

FINAL

FOR CONSTRUCTION

5

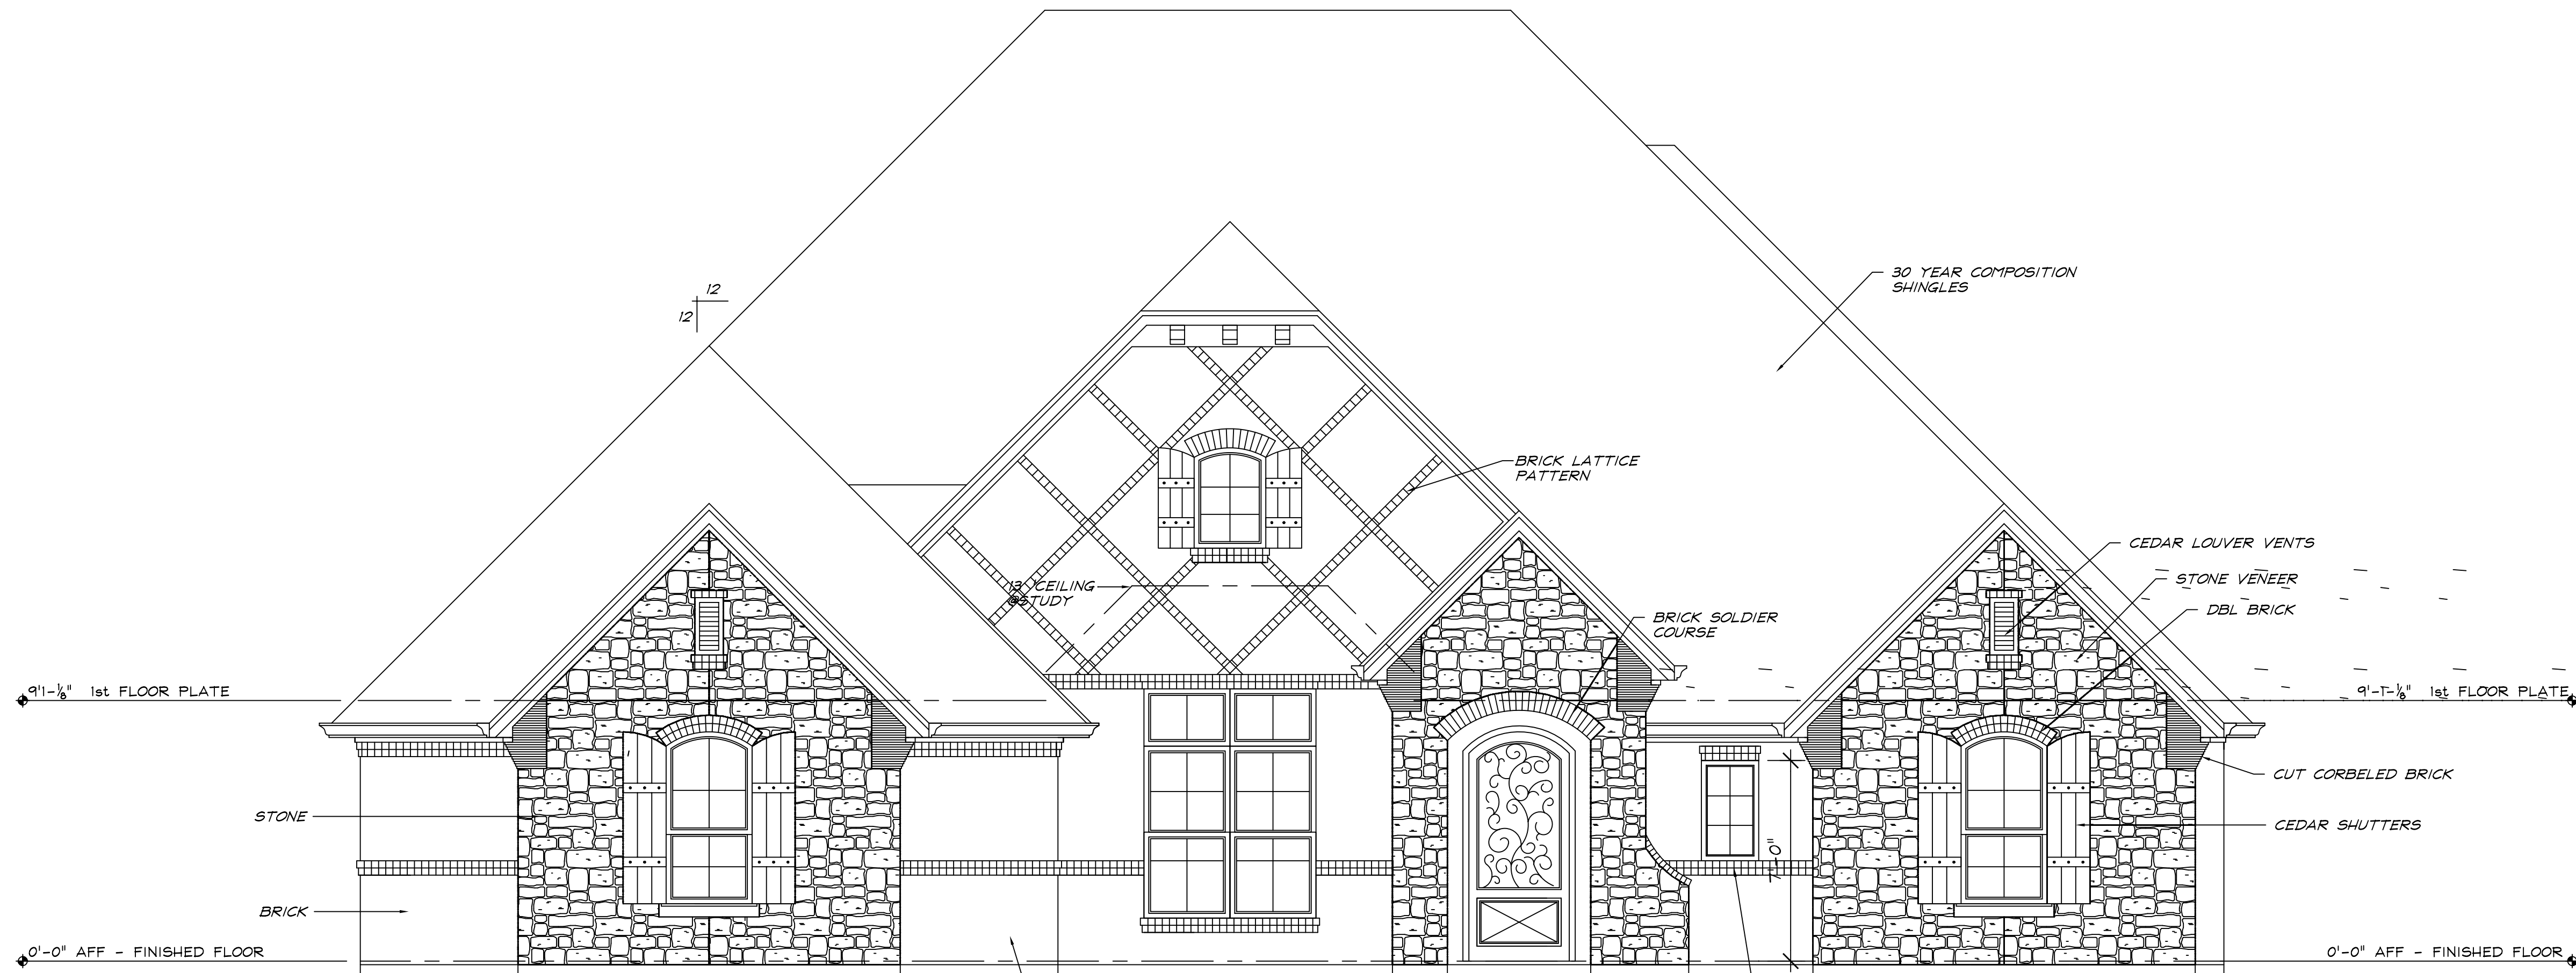


FRONT ELEVATION

SCALE: " = 1'-0"



REAR ELEVATION

SCALE: " = 1'-0"

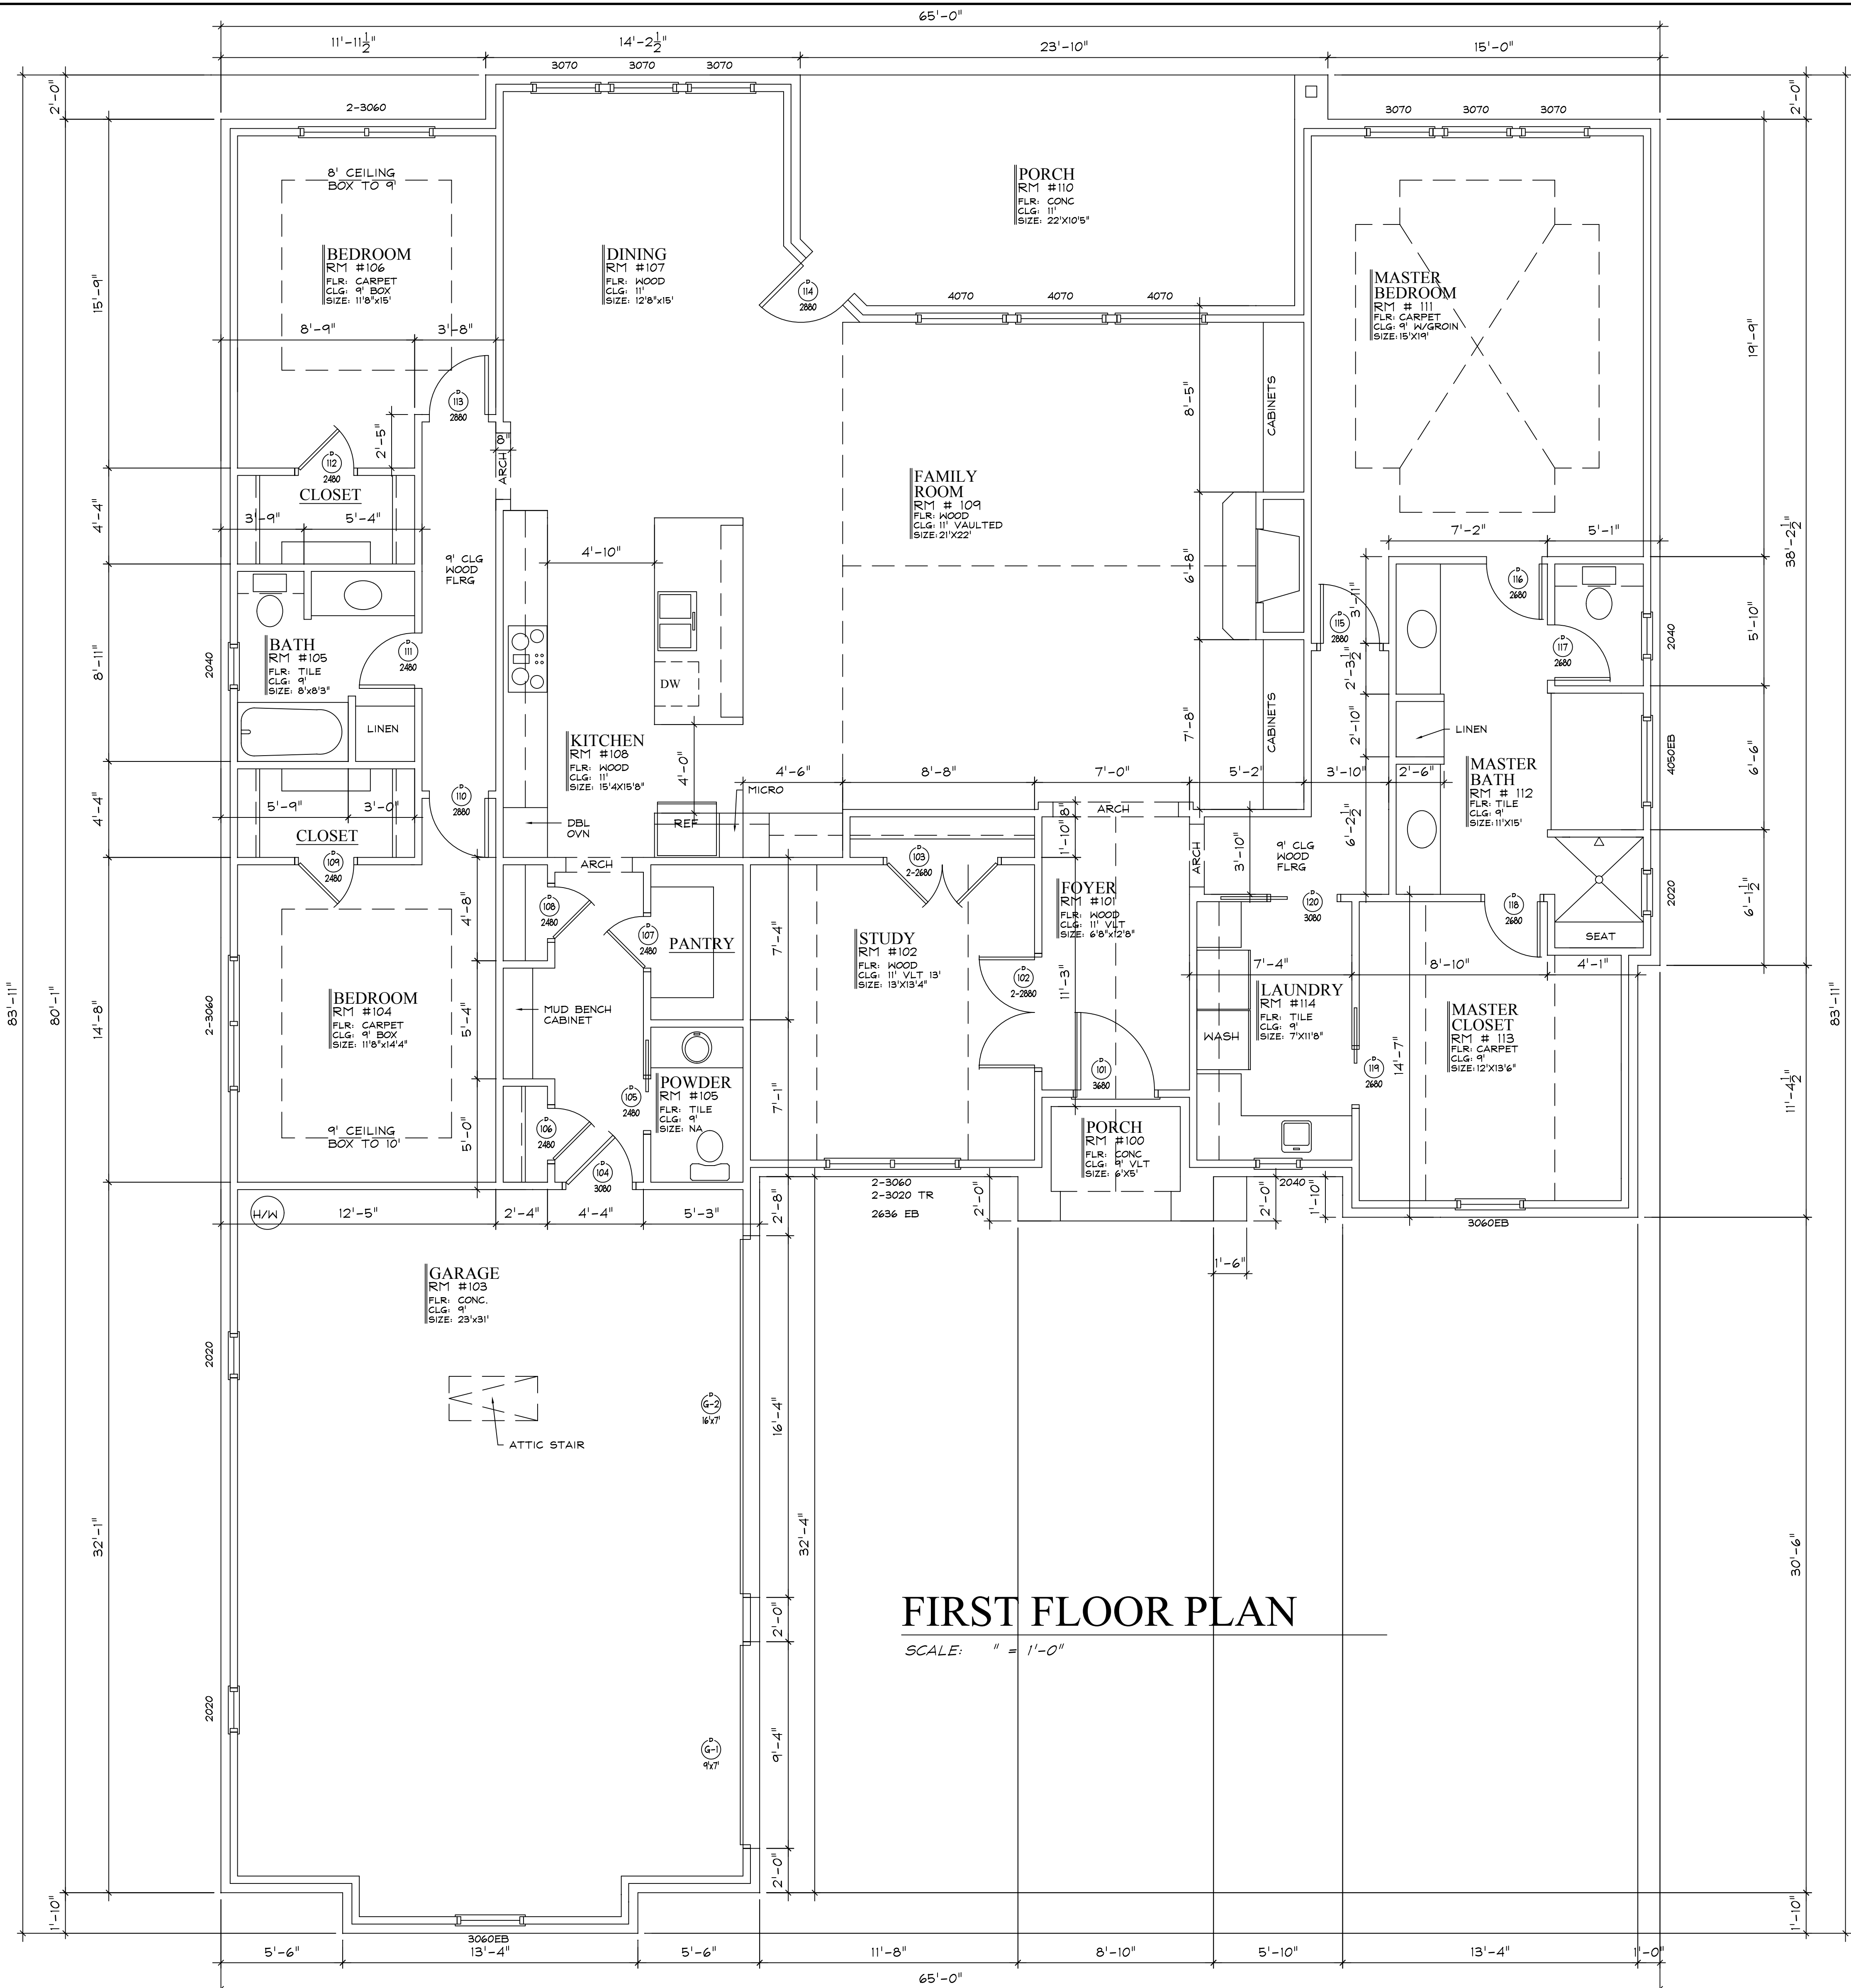

FIRST FLOOR PLAN

SCALE: 1" = 1'-0"

SHEET INDEX

#	DESCRIPTION
1	SITE PLAN
2	FOUNDATION PLAN
3	1ST FLOOR PLAN
4	ROOF PLAN
5	FRONT & REAR ELEVATIONS
6	SIDE ELEVATIONS
7	ELECTRICAL PLAN



PLAN # 5555
DATE: 2/4/11

COPYRIGHT 2011 R.D.S. ALL RIGHTS RESERVED. THESE DRAWINGS ARE THE EXCLUSIVE PROPERTY OF THE DESIGNER. NO PART OF THESE DRAWINGS MAY BE REPRODUCED OR TRANSMITTED IN ANY FORM OR BY ANY MEANS, WITHOUT THE EXPRESS WRITTEN PERMISSION OF THE DESIGNER. UNAUTHORIZED USE OF THESE DRAWINGS WILL BE PROSECUTED TO THE FULL EXTENT OF THE LAW.

3206 FALL CREEK HIGHWAY • GRANBURY, TX 76049
TEL: 817-332-2347 FAX: 817-332-2348
R.D.S. ARCHITECTURAL DESIGN, INC. IS A PROFESSIONAL ARCHITECTURAL FIRM. THE DESIGNER'S RESPONSIBILITY IS TO THE CLIENT AND THE RESPONSIBILITY OF THE RESPECTIVE ENGINEERS, ARCHITECTS, AND OTHER PROFESSIONALS IS TO THEIR RESPECTIVE CLIENTS. THE DESIGNER'S RESPONSIBILITY IS TO THE CLIENT AND THE RESPONSIBILITY OF THE RESPECTIVE ENGINEERS, ARCHITECTS, AND OTHER PROFESSIONALS IS TO THEIR RESPECTIVE CLIENTS.

PROJECT INFORMATION
CLIENT: RICHARDSON
150 BECKMAN CT
THE ISLAND CT
GRANBURY, TX

RESIDENTIAL
DESIGN STUDIO

SQUARE FOOTAGE	
1/8" = 1'	5'-12"
FIRST FLOOR AC.	2969
SECOND FLOOR AC.	0
GARAGE	797
PORCHES	271
TOTAL	4027

FINAL
FOR CONSTRUCTION